


PLANS
NOT
TO
SCALE

100' 0" 200' 0" 300' 0" 400' 0" 500' 0" 600' 0" 700' 0" 800' 0" 900' 0" 1000' 0"

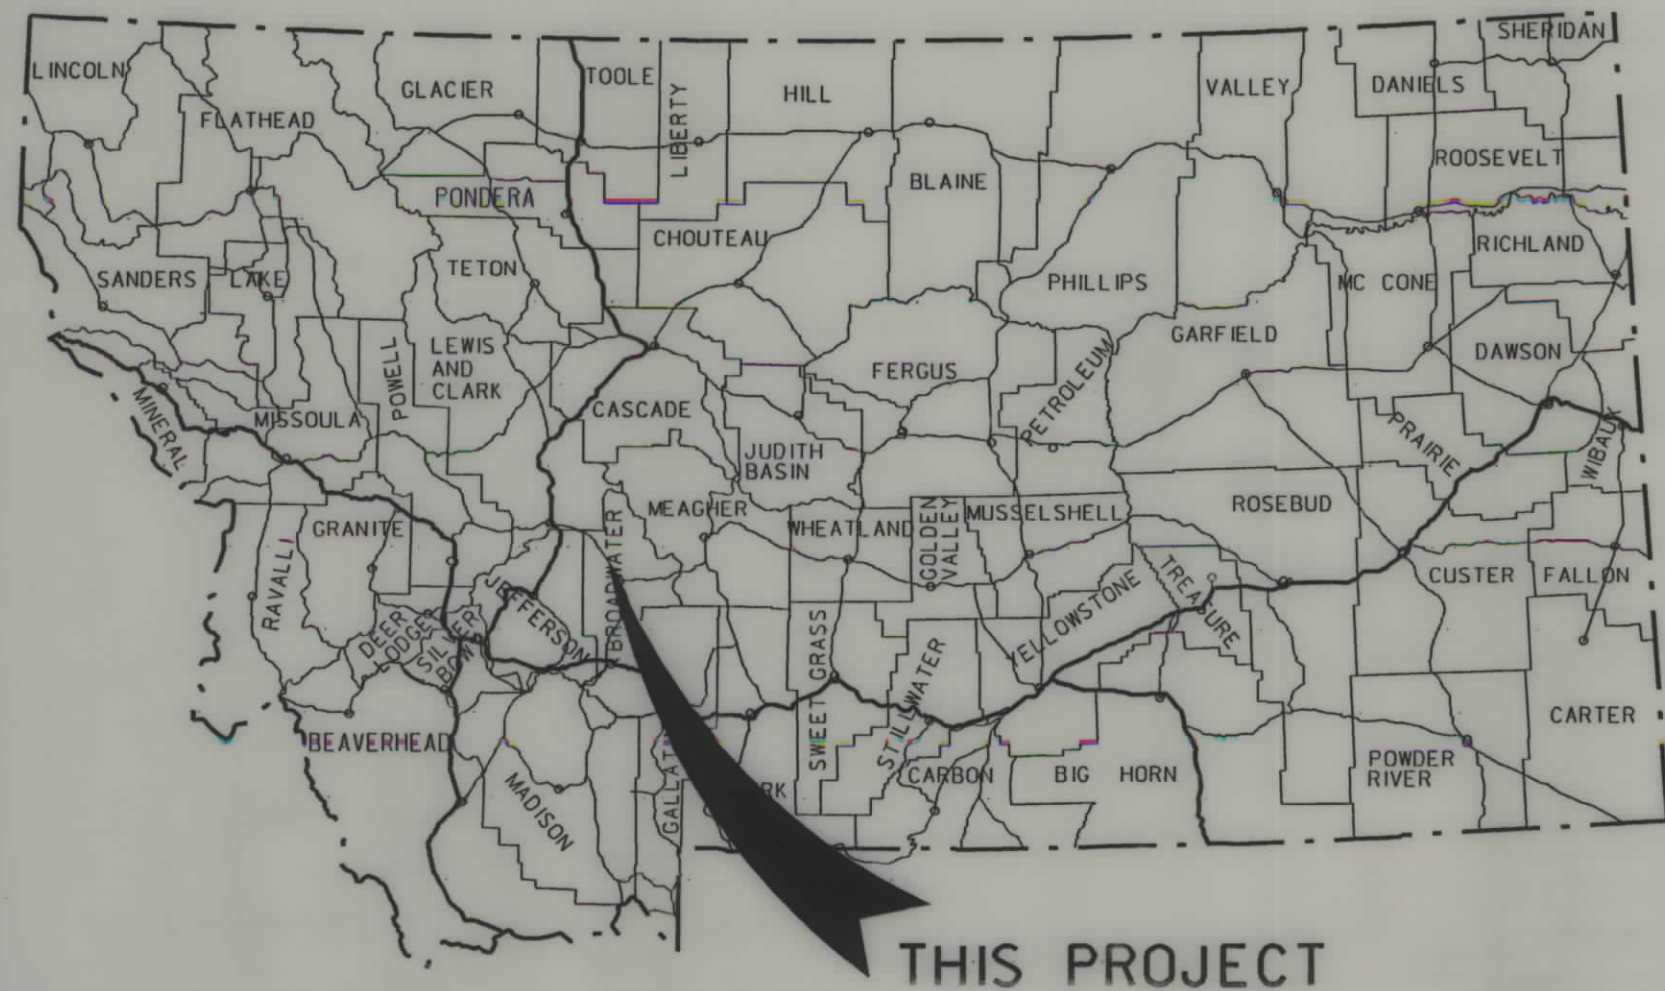

MONTANA DEPARTMENT OF TRANSPORTATION

STATE	RIGHT OF WAY ID.	SHEET NO.	TOTAL SHEETS
MONTANA	NH 8-4(27)58	1	12
PROJECT NUMBER 3377-027			
US 287 PASSING LANES (NORTH OF SILOS SECTION)			

RIGHT OF WAY PLAN OF FEDERAL AID PROJECT NH 8-4(27)58 US 287 PASSING LANES (NORTH OF SILOS SECTION) BROADWATER COUNTY

4.2 Kilometers



SEE SHEET NO. 2 FOR OWNERSHIP
NAMES, ADDRESSES, AREAS, ETC.

STA. 711+94.23 (FT) ON F-77(11) =
STA. 217+00.00 (m) BEGIN NH 8-1(20)58

STA. 849+73.75 (FT) ON F-77(11) =
STA. 259+00.00 (m) END NH 8-1(20)58

THIS CONTRACT
R.P. 68.02 TO R.P. 70.63

A CONTROLLED ACCESS FACILITY

CONTROLLED ACCESS RESOLUTION IS RECORDED IN BK 53 MICRO PG 172 OF THE
OFFICIAL RECORDS OF BROADWATER COUNTY, MONTANA

NOTES: 1. ALL MEASUREMENTS ARE METRIC EXCEPT AS NOTED

CONVENTIONAL SIGNS

PROPOSED RIGHT OF WAY LINE	---
EXISTING RIGHT OF WAY LINE	---
RAILROAD RIGHT OF WAY LINE	---
CENTERLINE (C) OR PROJECTED LINE	---
STK'D CENTERLINE	---
SECTION LINE	---
OWNERSHIP BOUNDARY	---
FULL ACCESS CONTROL	AC AC
LIMITED ACCESS CONTROL	/// ///
EXISTING ACCESS CONTROL	/// ///
PRESENT TRAVELED WAY (P.T.V.)	---
FENCE LINE	---
EXISTING GUARDRAIL	---
PROPOSED GUARDRAIL	---
GATE IN FENCE	---
CATTLE GUARD: EXIST. - PROPOSED	---
SECTION CORNER	FOUND UNFOUND
1/4 SECTION CORNER	---
CLOSING CORNER	---
MEANDER CORNER	---
CENTER OF SECTION	---
RIGHT OF WAY MONUMENT	---
PROPERTY CORNER PIN	---
POWER POLE IN PLACE	---
TELEPHONE POLE IN PLACE	---
TELEGRAPH POLE IN PLACE	---
LIGHT POLE	---
PROPOSED CULVERT	---
EXISTING CULVERT	---
OUTLET DITCH	---
INLET DITCH	---
EXISTING DITCH	---
CHANNEL CHANGES	---
DITCH BLOCK	---
RIPRAP	---
BRIDGES	---
RAILROADS	---
PARCEL NUMBERS	---
APPROACH: EXIST.- PROPOSED	---

ASSOCIATED PROJECT ID.
NH 8-4(20)58 PE

RELATED PROJECTS
F 77(11) AS-BUILT

FHWA/MDT APPROVAL	7/31/01
MAP REVISED	

RDROW

MONTANA
CADD

3
2
1

MONTANA DEPARTMENT
OF TRANSPORTATION

MONTANA
DOT
11111\PO\3377\POA_GADD

RD ROW

... \3377\DOWN, ROW
01/29/02
03:39:41 PM
3 2 1
U7713

OWNERSHIP																			
PARCEL	NAME	ADDRESS	TOTAL	AREA	GROSS R/W AREA		EX. EASE. AREA		NET AREA		REMAINDER				CONST. PMT. AREA		EASE. AREA		SHEET NO.
			METRIC	ENGLISH	METRIC	ENGLISH	METRIC	ENGLISH	METRIC	ENGLISH	LEFT		RIGHT		METRIC	ENGLISH	METRIC	ENGLISH	
											METRIC	ENGLISH	METRIC	ENGLISH					
2-1	WINSTON LIVESTOCK COMPANY, A MT CORP	P.O. BOX 470173, WINSTON, MT 59647			FOR	ACCESS CONTROL ONLY													5, 6, 7
2-2	WINSTON LIVESTOCK COMPANY, A MT CORP	P.O. BOX 470173, WINSTON, MT 59647	64.750+ ha	160.00+ AC	0.355 ha	0.88 AC			0.355 ha	0.88 AC									5, 6, 7
2-1&2-2	COMBINATION PARCEL		64.750+ ha	160.00+ AC	0.355 ha	0.88 AC			0.355 ha	0.88 AC									5, 6, 7
2-3	U.S.A., DEPARTMENT OF THE INTERIOR,	1245 NORTH 29TH ST., BILLINGS, MT	64.750+ ha	160.00+ AC	8.408 ha	20.78 AC	7.659 ha	18.93 AC	0.749 ha	1.85 AC									7, 8
	BUREAU OF LAND MANAGEMENT																		
2-4	JOE Z. JEPSON & KATHLEEN C. JEPSON	P.O. DRAWER B, TOWNSEND, MT 59644			FOR	ACCESS CONTROL ONLY													8, 9
2-5	ROBERT R. SCOTT & JOANNE SCOTT	6960 HWY 287 EAST, TOWNSEND, MT 59644			FOR	ACCESS CONTROL ONLY													8, 9
2-6	MIRIAM A. HATCHER	16012 121ST AVE. E., PUYALLUP, WA 98374	8.554 ha	21.138 AC	0.391 ha	0.96 AC	0.017 ha	0.04 AC	0.374 ha	0.92 AC			8.163 ha	20.178 AC					9, 12
2-7	WARREN B. & CHARLENE M. ADAMS	6735 HIGHWAY 12 EAST, EAST HELENA, MT 59635			FOR	ACCESS CONTROL ONLY													9, 10, 12
	C/D ERNEST R. & CAROLYN J. NUNN	7191 HIGHWAY 287, TOWNSEND, MT 59644																	
2-8	RONALD JEFFREY STOFFER	P.O. BOX 625, TOWNSEND, MT 59644-0625	7.288 ha	18.01 AC													* 0.567 ha	* 1.40 AC	9, 10, 12
2-9	U.S.A., DEPARTMENT OF THE INTERIOR	1245 NORTH 29TH ST., BILLINGS, MT	64.750+ ha	160.00+ AC													0.041 ha	0.10 AC	9-12
	BUREAU OF LAND MANAGEMENT																		
2-3&2-9	COMBINATION PARCEL		64.750+ ha	160.00+ AC	8.408 ha	20.78 AC	7.659 ha	18.93 AC	**0.790 ha	**1.95 AC							**	**	7, 8, 9-12
2-10	ANTELOPE ACRES HOMEOWNERS ASSOC.	1338 11TH AVE., HELENA, MT 59601			FOR	ACCESS CONTROL ONLY													9, 12
	C/O SAM A. YOUNG, ETAL																		

* TO BE ACQUIRED AS EASEMENT IN THE NAME OF BROADWATER COUNTY
** NET AREA INCLUDES 0.041 ha (0.10 AC) LABELED AS EASEMENT ON PLAN SHEETS

STATE	RIGHT OF WAY ID.	SHEET	TOTAL
		NO.	SHEETS
MONTANA	NH 8-4(27)58	2	12
PROJECT NUMBER 3377-027			

US 287 PASSING LANES
(NORTH OF SILOS SECTION)

- NOTES: 1. ALL MEASUREMENTS ARE METRIC EXCEPT AS NOTED
2. THE PROPOSED R/W LINE WHERE A SPIRAL CURVE TRANSITION IS USED IS A CHORD RATHER THAN A CONCENTRIC CURVE.
3. THE ENGLISH AREAS ARE FOR INFORMATIONAL PURPOSES ONLY.
4. ALL STATIONS AND OFFSETS FOR R/W BREAKS ARE IN REFERENCE TO THE R/W BASELINE.

BACKSLOPE LIMITS INCLUDE ROUNDING	
CONSTRUCTION LIMITS: 	
FHWA/ODT APPROVAL 7/31/01	
MAP REVISED 8/30/01 11/19/01 12/7/01	
1/29/02	

MONTANA
DEPARTMENT OF TRANSPORTATION

RIGHT OF WAY PLAN
BROADWATER COUNTY

MONTANA
DEPARTMENT OF TRANSPORTATION

RIGHT OF WAY PLAN
BROADWATER COUNTY

STATE	RIGHT OF WAY ID.	SHEET NO.	TOTAL SHEETS
MONTANA	NH 8-4(27)58	4	12
PROJECT NUMBER 3377-027			

US 287 PASSING LANES
(NORTH OF SILOS SECTION)

GPS CONTROL ABSTRACT					
POINT NUMBER	NORTHING	EASTING	STATION ELEVATION	GROUND ELEVATION	LOCATION DESCRIPTION
21028	246051.9908	437077.1801	1257.6415		HUB AND TACK; 38.43m LEFT OF STATION 210+28.75
21183	245884.8278	437105.0596	1254.4513		51mm A.C.; 29.85m RIGHT OF STATION 211+83.86
22343	244914.6849	437740.5528	1231.1098		51mm A.C.; 29.84m RIGHT OF STATION 223+43.62
22897	244488.7478	438101.1692	1219.2022		19mm I.P.; 38.42m LEFT OF STATION 228+97.52
23943	243613.9376	438675.6343	1205.3017		19mm I.P.; 39.61m LEFT OF STATION 239+44.09
24993	242697.4269	439191.9605	1197.2410		19mm I.P.; 30.68m RIGHT OF STATION 249+93.68
1SP	242202.5050	439518.7368	1193.7490		51mm A.C.; 28.51m RIGHT OF STATION 255+86.75

GPS CONTROL DIAGRAM
NOT TO SCALE

- NOTES: 1. ALL MEASUREMENTS ARE METRIC EXCEPT AS NOTED
2. THE PROPOSED R/W LINE WHERE A SPIRAL CURVE TRANSITION IS USED IS A CHORD RATHER THAN A CONCENTRIC CURVE.
3. THE ENGLISH AREAS ARE FOR INFORMATIONAL PURPOSES ONLY.
4. ALL STATIONS AND OFFSETS FOR R/W BREAKS ARE IN REFERENCE TO THE R/W BASE LINE

BACKSLOPE LIMITS INCLUDE ROUNDING	TOP OF CUT
CONSTRUCTION LIMITS:	CUT SECTION
	TOE OF FILL
	DITCH BOTTOM
FHWA/DOT APPROVAL	7/31/01
MAP REVISED	

MONTANA
DEPARTMENT OF TRANSPORTATION
RIGHT OF WAY PLAN
BROADWATER COUNTY

MONTANA
DEPARTMENT OF TRANSPORTATION
RIGHT OF WAY PLAN
BROADWATER COUNTY
SCALE 1:1000

SEE SHEET NO. 2 FOR OWNERSHIP NAMES, ADDRESSES, AREAS, ETC.


[illegible]

(1) MOVABLE ROAD APPROACHES MAY BE RELOCATED BETWEEN THE SPECIFIED STATIONS AFTER THE INITIAL RECONSTRUCTION. A PERMIT MUST BE OBTAINED FROM THE MOOT OFFICE IN BUTTE.

(2) JOINT-USE ROAD APPROACH RELOCATIONS "RESTRICTED".

STATE	RIGHT OF WAY ID.	SHEET	TOTAL
		NO.	SHEETS
MONTANA	NH 8-4(27)58	6	12
PROJECT NUMBER 3377-027			

US 287 PASSING LANES
(NORTH OF SILOS SECTION)

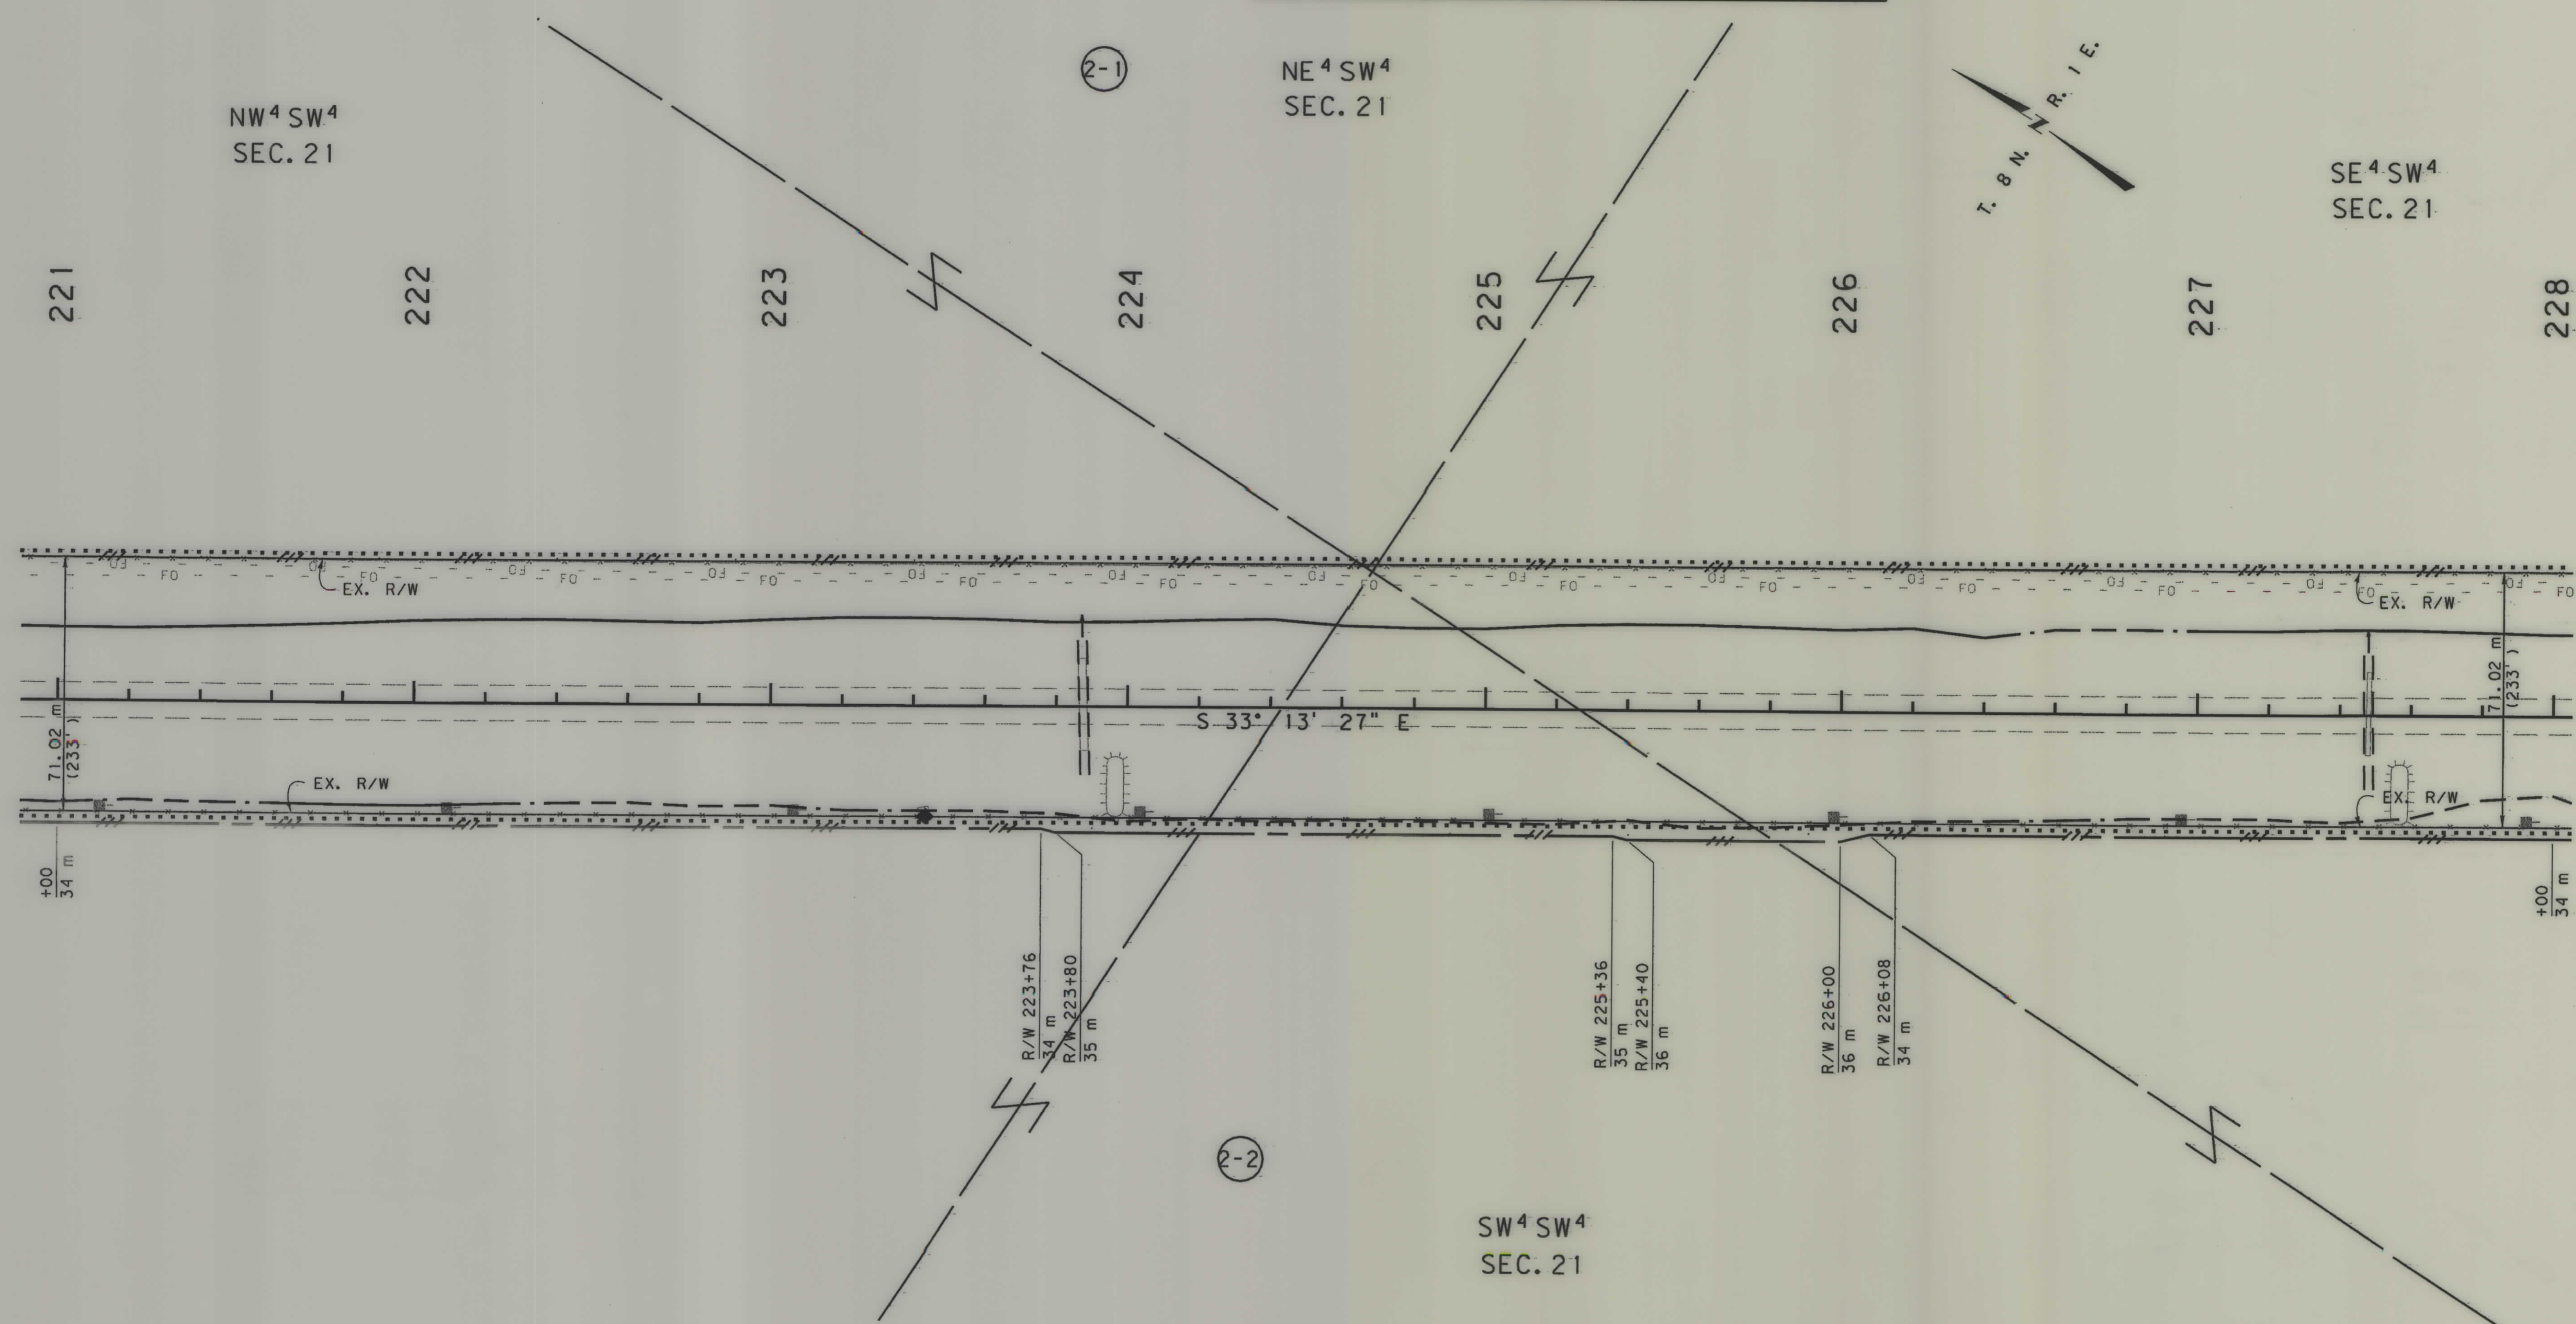

- NOTES: 1. ALL MEASUREMENTS ARE METRIC EXCEPT AS NOTED
2. THE PROPOSED R/W LINE WHERE A SPIRAL CURVE TRANSITION IS USED IS A CHORD RATHER THAN A CONCENTRIC CURVE.
3. THE ENGLISH AREAS ARE FOR INFORMATIONAL PURPOSES ONLY.
4. ALL STATIONS AND OFFSETS FOR R/W BREAKS ARE IN REFERENCE TO THE R/W BASELINE.

BACKSLOPE LIMITS INCLUDE ROUNDING
CONSTRUCTION LIMITS: CUT SECTION
TOE OF FILL

TOP OF CUT
DITCH BOTTOM

 
FWHA/DOT APPROVAL 7/31/01

MAP REVISED 8/30/01

MONTANA
DEPARTMENT OF TRANSPORTATION

RIGHT OF WAY PLAN
BROADWATER COUNTY

SCALE 1"=1000'

A horizontal graphic scale bar with alternating black and white segments, representing a distance of 1000 feet. The bar is located at the bottom of the page, below the text 'SCALE 1"=1000''.

SEE SHEET NO. 2 FOR OWNERSHIP NAMES, ADDRESSES, AREAS, ETC.


[illegible]

(1) MOVABLE ROAD APPROACHES MAY BE RELOCATED BETWEEN THE SPECIFIED STATIONS AFTER THE INITIAL RECONSTRUCTION. A PERMIT MUST BE OBTAINED FROM THE MOOT OFFICE IN BUTTE.

(2) JOINT-USE ROAD APPROACH RELOCATIONS
"RESTRICTED".

STATE	RIGHT OF WAY ID.	SHEET	TOTAL
		NO.	SHEETS
MONTANA	NH 8-4(27)58	7	12
PROJECT NUMBER 3377-027			

US 287 PASSING LANES
(NORTH OF SILOS SECTION)

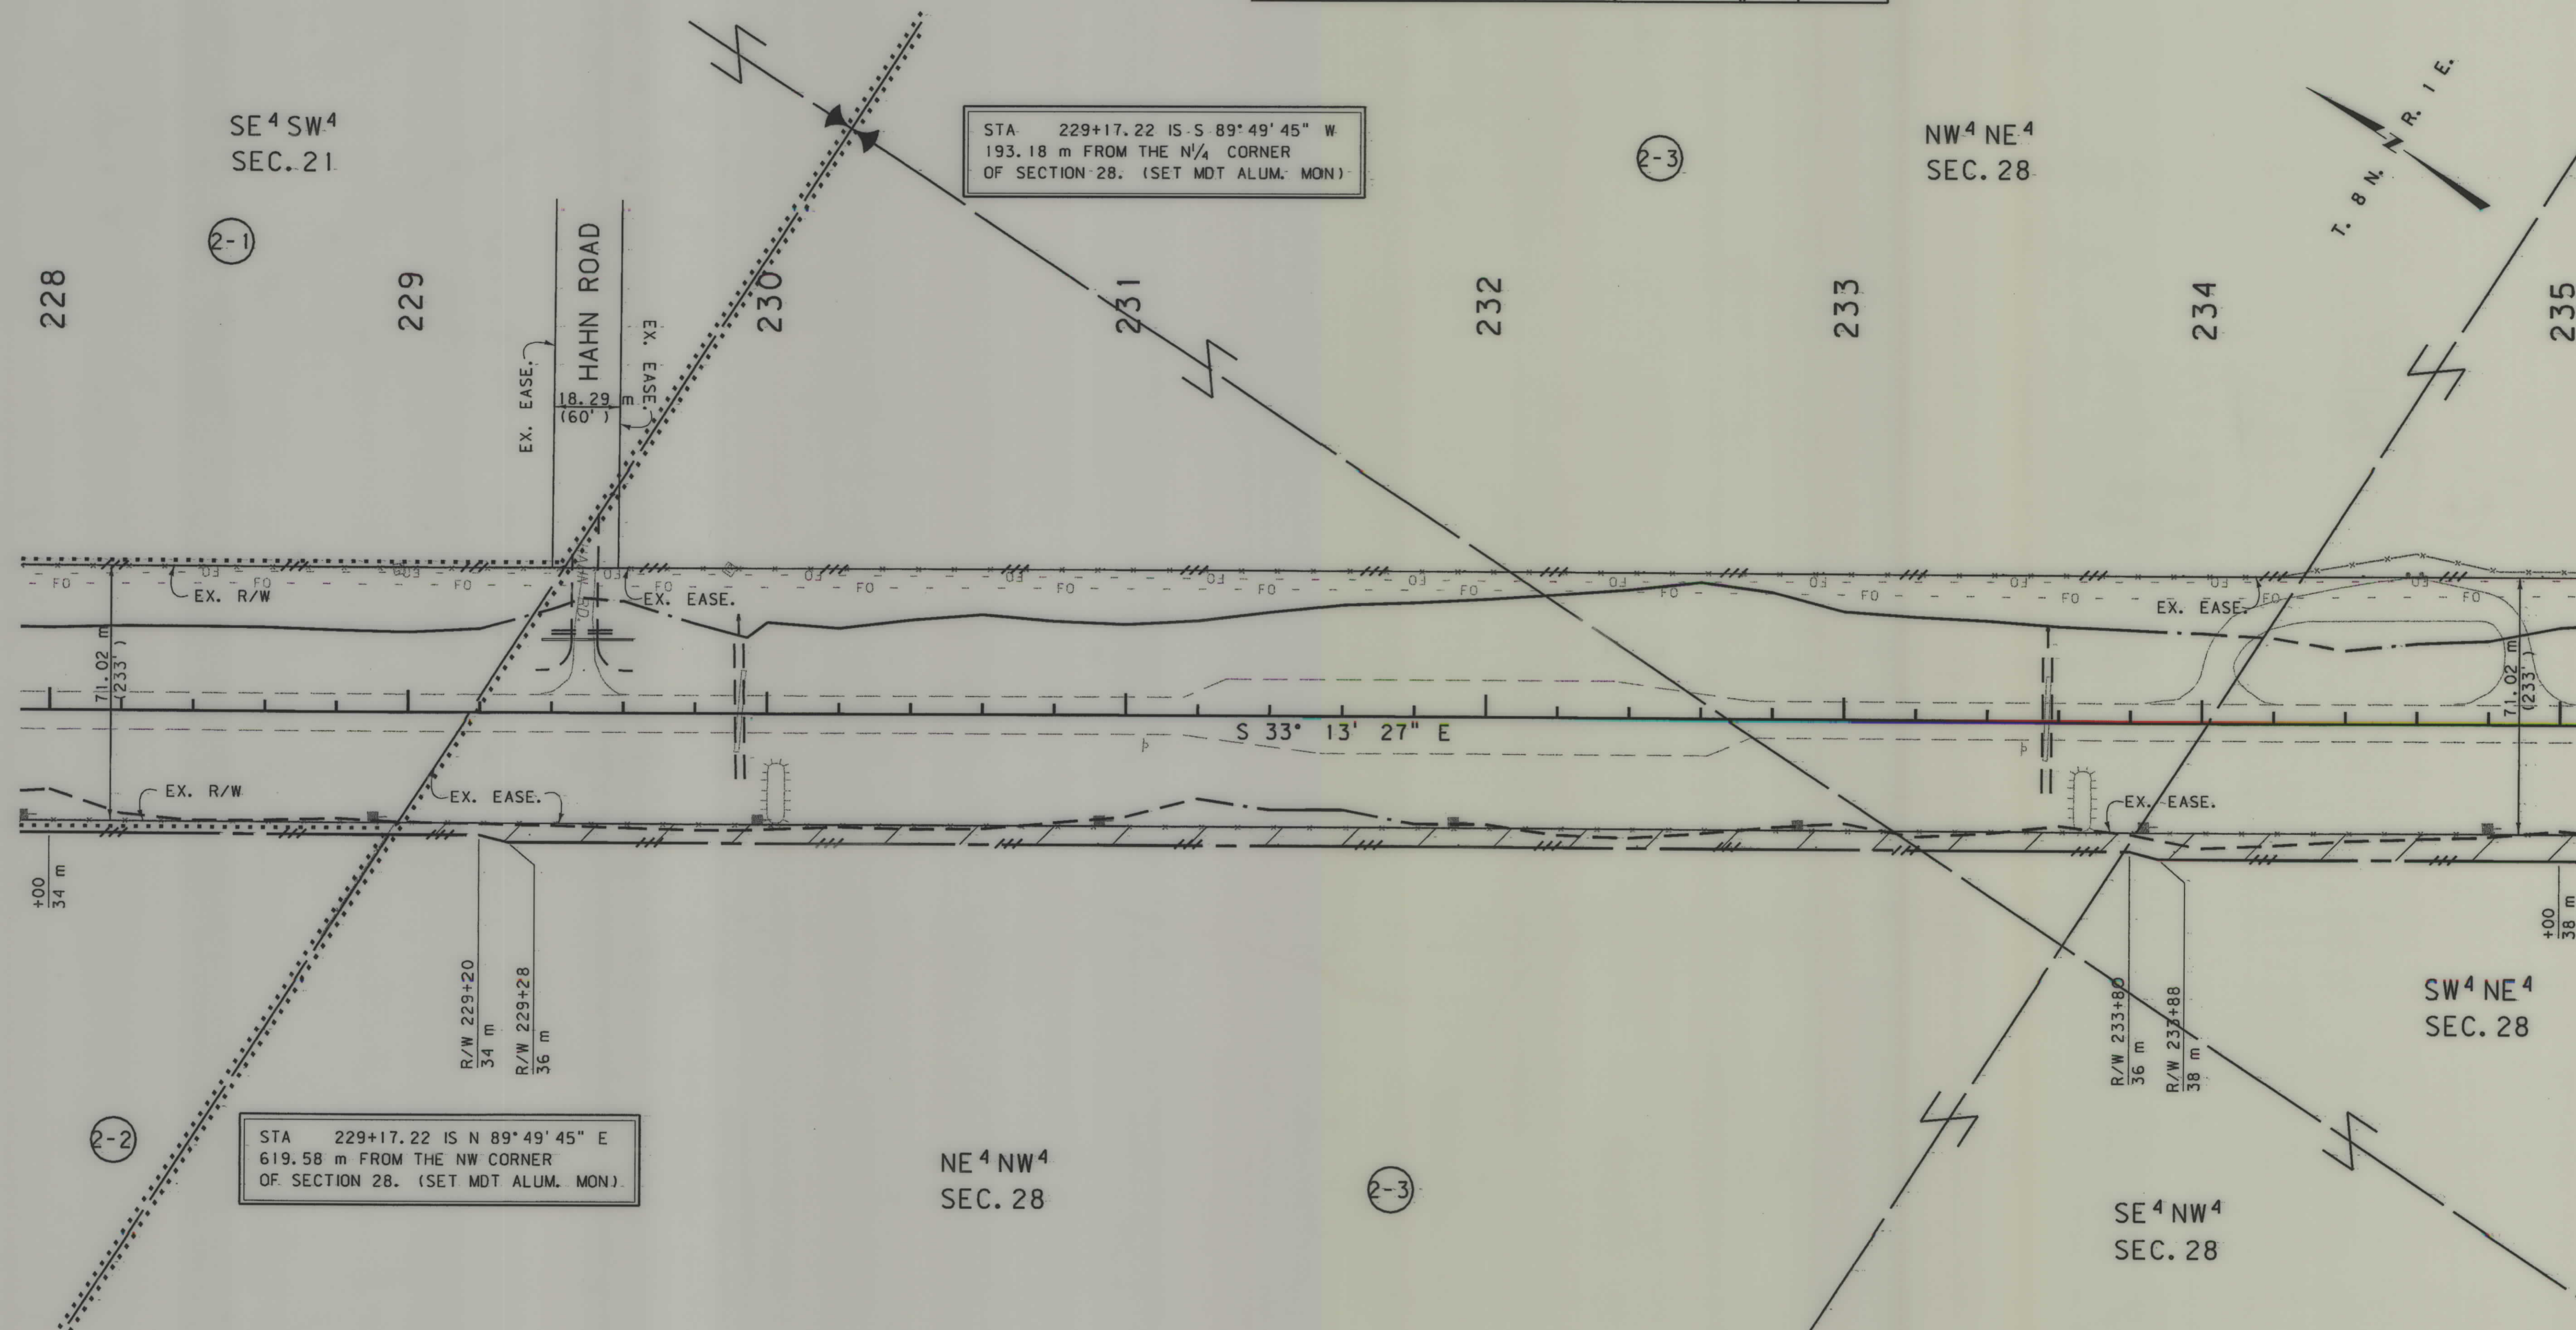

- NOTES: 1. ALL MEASUREMENTS ARE METRIC EXCEPT AS NOTED
2. THE PROPOSED R/W LINE WHERE A SPIRAL CURVE TRANSITION IS USED IS A CHORD RATHER THAN A CONCENTRIC CURVE.
3. THE ENGLISH AREAS ARE FOR INFORMATIONAL PURPOSES ONLY.
4. ALL STATIONS AND OFFSETS FOR R/W BREAKS ARE IN REFERENCE TO THE R/W BASELINE.

 
BACKSLOPE LIMITS INCLUDE ROUNDING.
CONSTRUCTION LIMITS:

CUT SECTION
TOE OF FILL

FHWA/DOT APPROVAL 7/31/01
MAP REVISED 8/30/01

MONTANA
DEPARTMENT OF TRANSPORTATION

RIGHT OF WAY PLAN
BROADWATER COUNTY
SCALE 1" = 1000'



3377\ro\33772p\02\RDROW

RDROW


33772P\02.RDROW
01/29/02
03:40:50 PM
UT 7 13

SEE SHEET NO. 2 FOR OWNERSHIP NAMES, ADDRESSES, AREAS, ETC.

ROAD APPROACHES						
PRIVATE					PUBLIC	
PARCELS SERVED	NO. OF APP.	SIDE	MOVABLE (1) LIMITS		FIXED LOCATION	STATION
			FROM STA.	TO STA.		
2-5	1	RT	240+53	242+32		

(1) MOVABLE ROAD APPROACHES MAY BE RELOCATED BETWEEN THE SPECIFIED STATIONS AFTER THE INITIAL RECONSTRUCTION. A PERMIT MUST BE OBTAINED FROM THE MDT OFFICE IN BUTTE.
(2) JOINT-USE ROAD APPROACH RELOCATIONS "RESTRICTED".

STATE	RIGHT OF WAY ID.	SHEET NO.	TOTAL SHEETS
MONTANA	NH 8-4(27)58	8	12
PROJECT NUMBER 3377-027			
US 287 PASSING LANES (NORTH OF SILOS SECTION)			

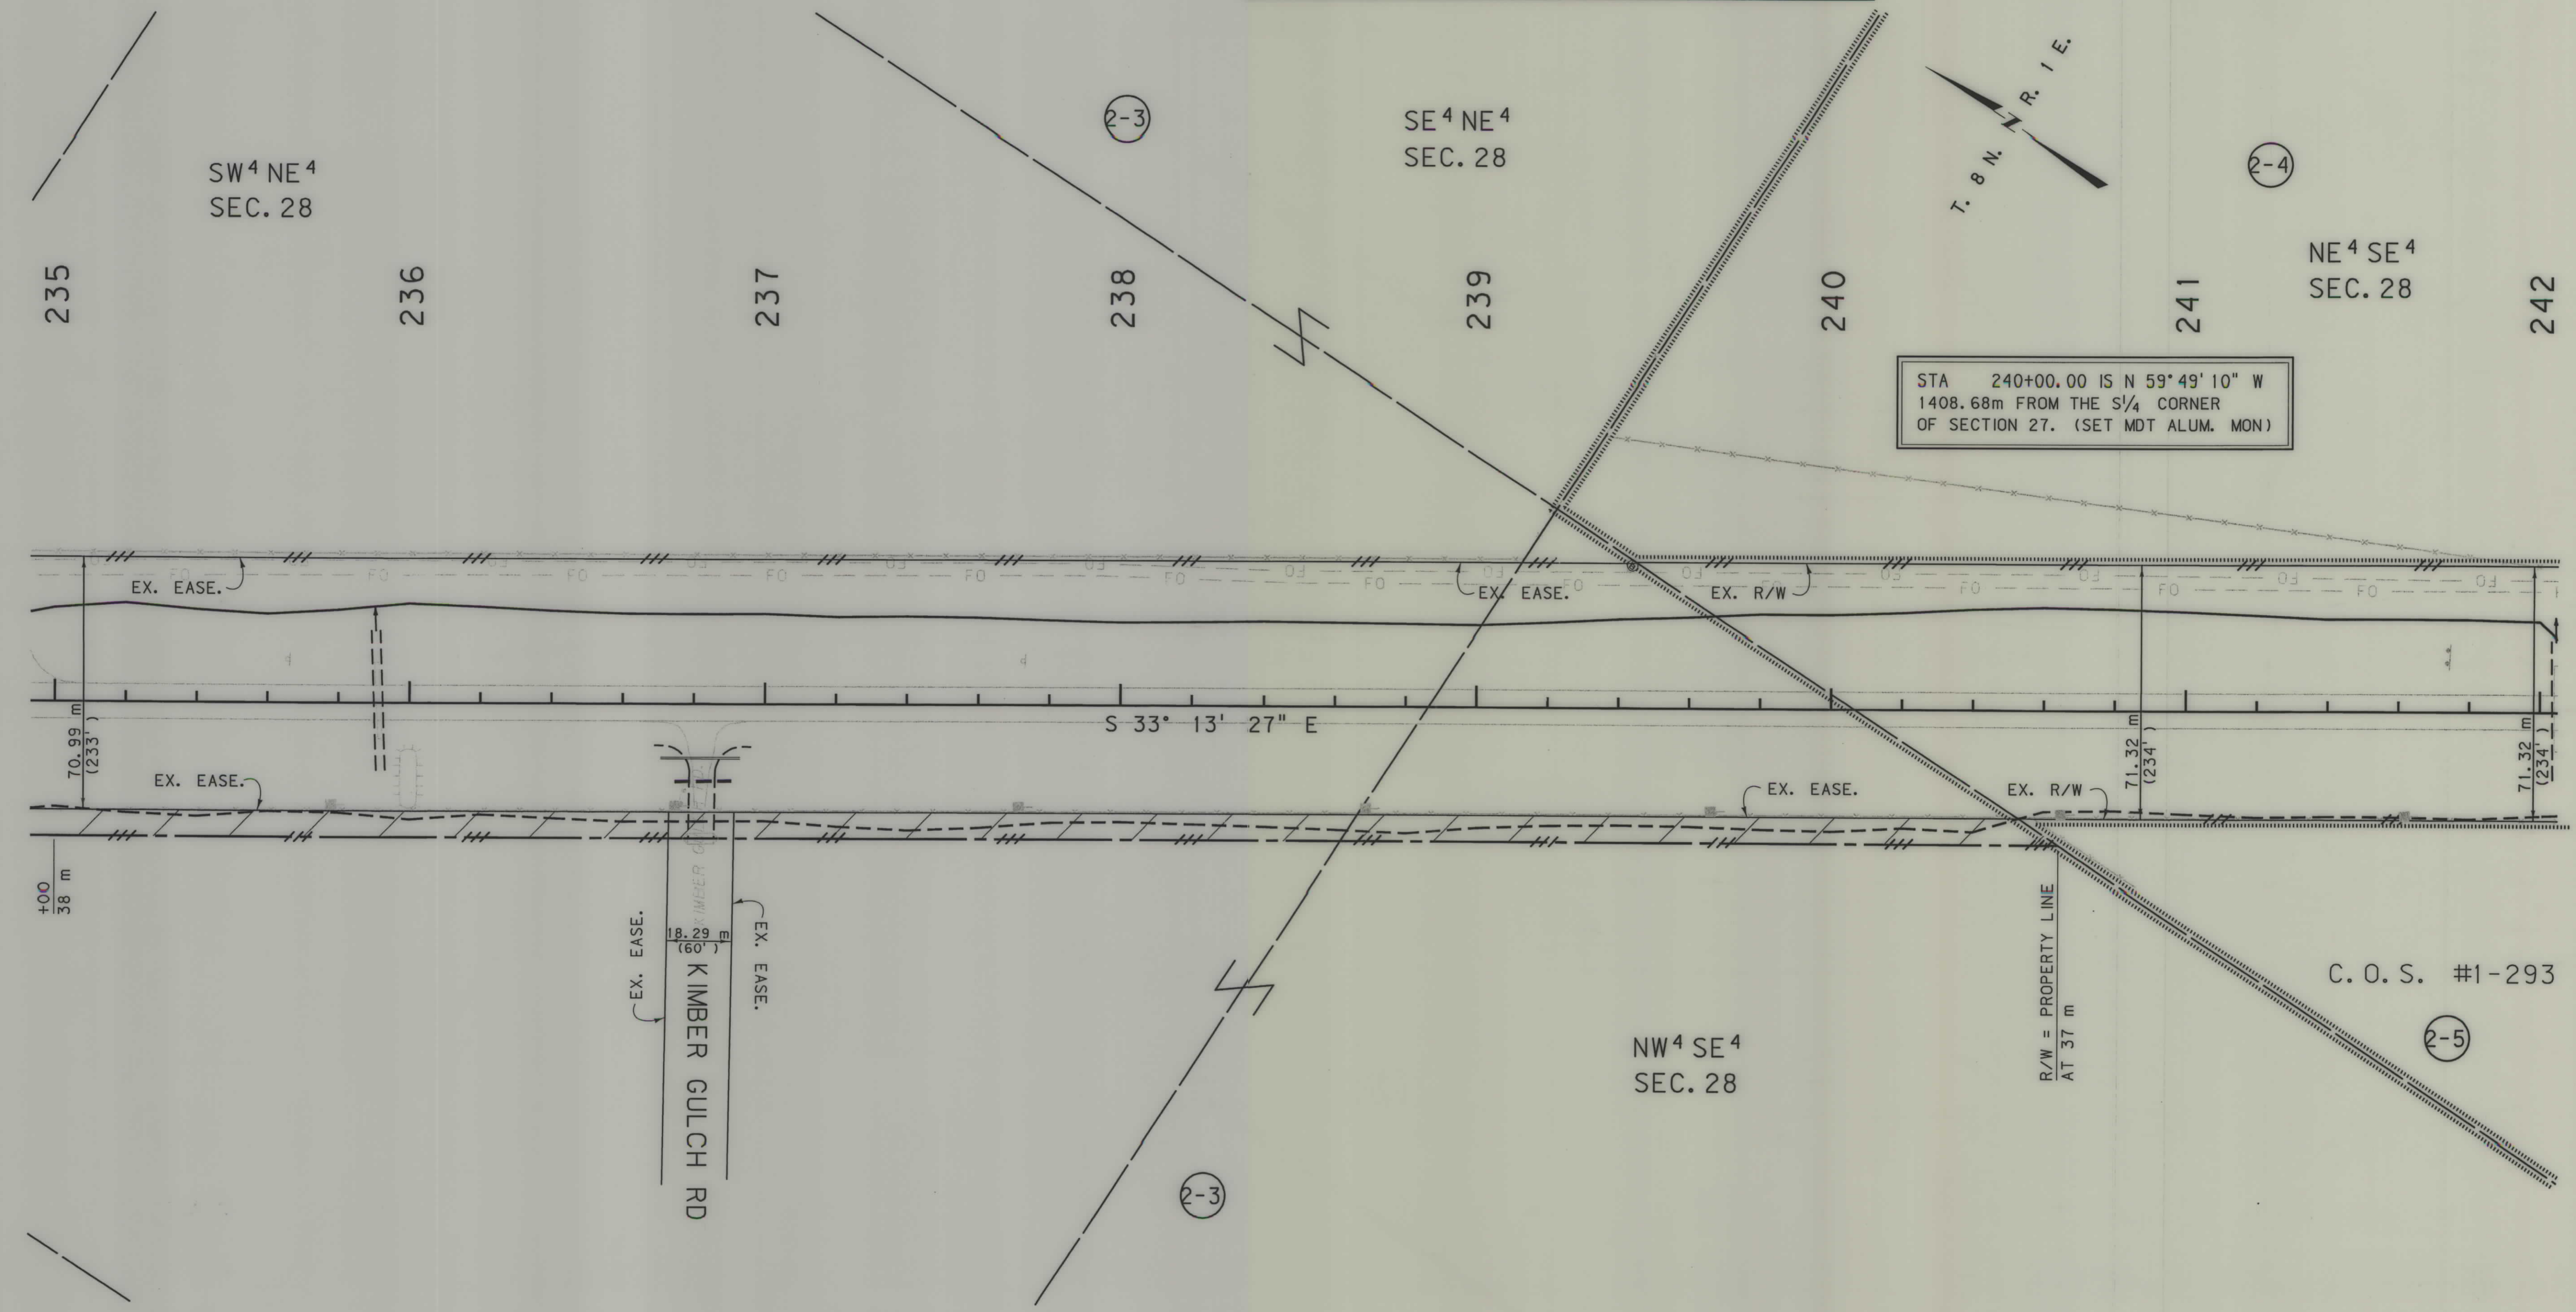

- NOTES: 1. ALL MEASUREMENTS ARE METRIC EXCEPT AS NOTED
2. THE PROPOSED R/W LINE WHERE A SPIRAL CURVE TRANSITION IS USED IS A CHORD RATHER THAN A CONCENTRIC CURVE.
3. THE ENGLISH AREAS ARE FOR INFORMATIONAL PURPOSES ONLY.
4. ALL STATIONS AND OFFSETS FOR R/W BREAKS ARE IN REFERENCE TO THE R/W BASELINE.

BACKSLOPE LIMITS INCLUDE ROUNDING	
CONSTRUCTION LIMITS:	CUT SECTION
	TOE OF FILL
FHWA/DOT APPROVAL 7/31/01	
MAP REVISED 8/30/01 11/19/01 1/29/02	

MONTANA
DEPARTMENT OF TRANSPORTATION

RIGHT OF WAY PLAN
BROADWATER COUNTY
SCALE 1:1000

SEE SHEET NO. 2 FOR OWNERSHIP NAMES, ADDRESSES, AREAS, ETC.


ROAD APPROACHES							
PRIVATE					PUBLIC		
PARCELS SERVED	NO. OF APP.	SIDE	MOVABLE (1)		JOINT-USE (2)		
			LIMITS		FIXED LOCATION	SIDE	STATION
			FROM STA.	TO STA.			
2-5	1	RT	240+53	242+32			
2-6	1	RT	242+32	248+36			
						RT 248+66	
						LT 249+04	

(1) MOVABLE ROAD APPROACHES MAY BE RELOCATED BETWEEN THE SPECIFIED STATIONS AFTER THE INITIAL RECONSTRUCTION. A PERMIT MUST BE OBTAINED FROM THE MDOT OFFICE IN BUTTE.

(2) JOINT-USE ROAD APPROACH RELOCATIONS
"RESTRICTED".

STATE	RIGHT OF WAY ID.	SHEET	TOTAL
		NO.	SHEETS
MONTANA	NH 8-4(27)58	9	12
PROJECT NUMBER 3377-027			

US 287 PASSING LANES
(NORTH OF SILOS SECTION)

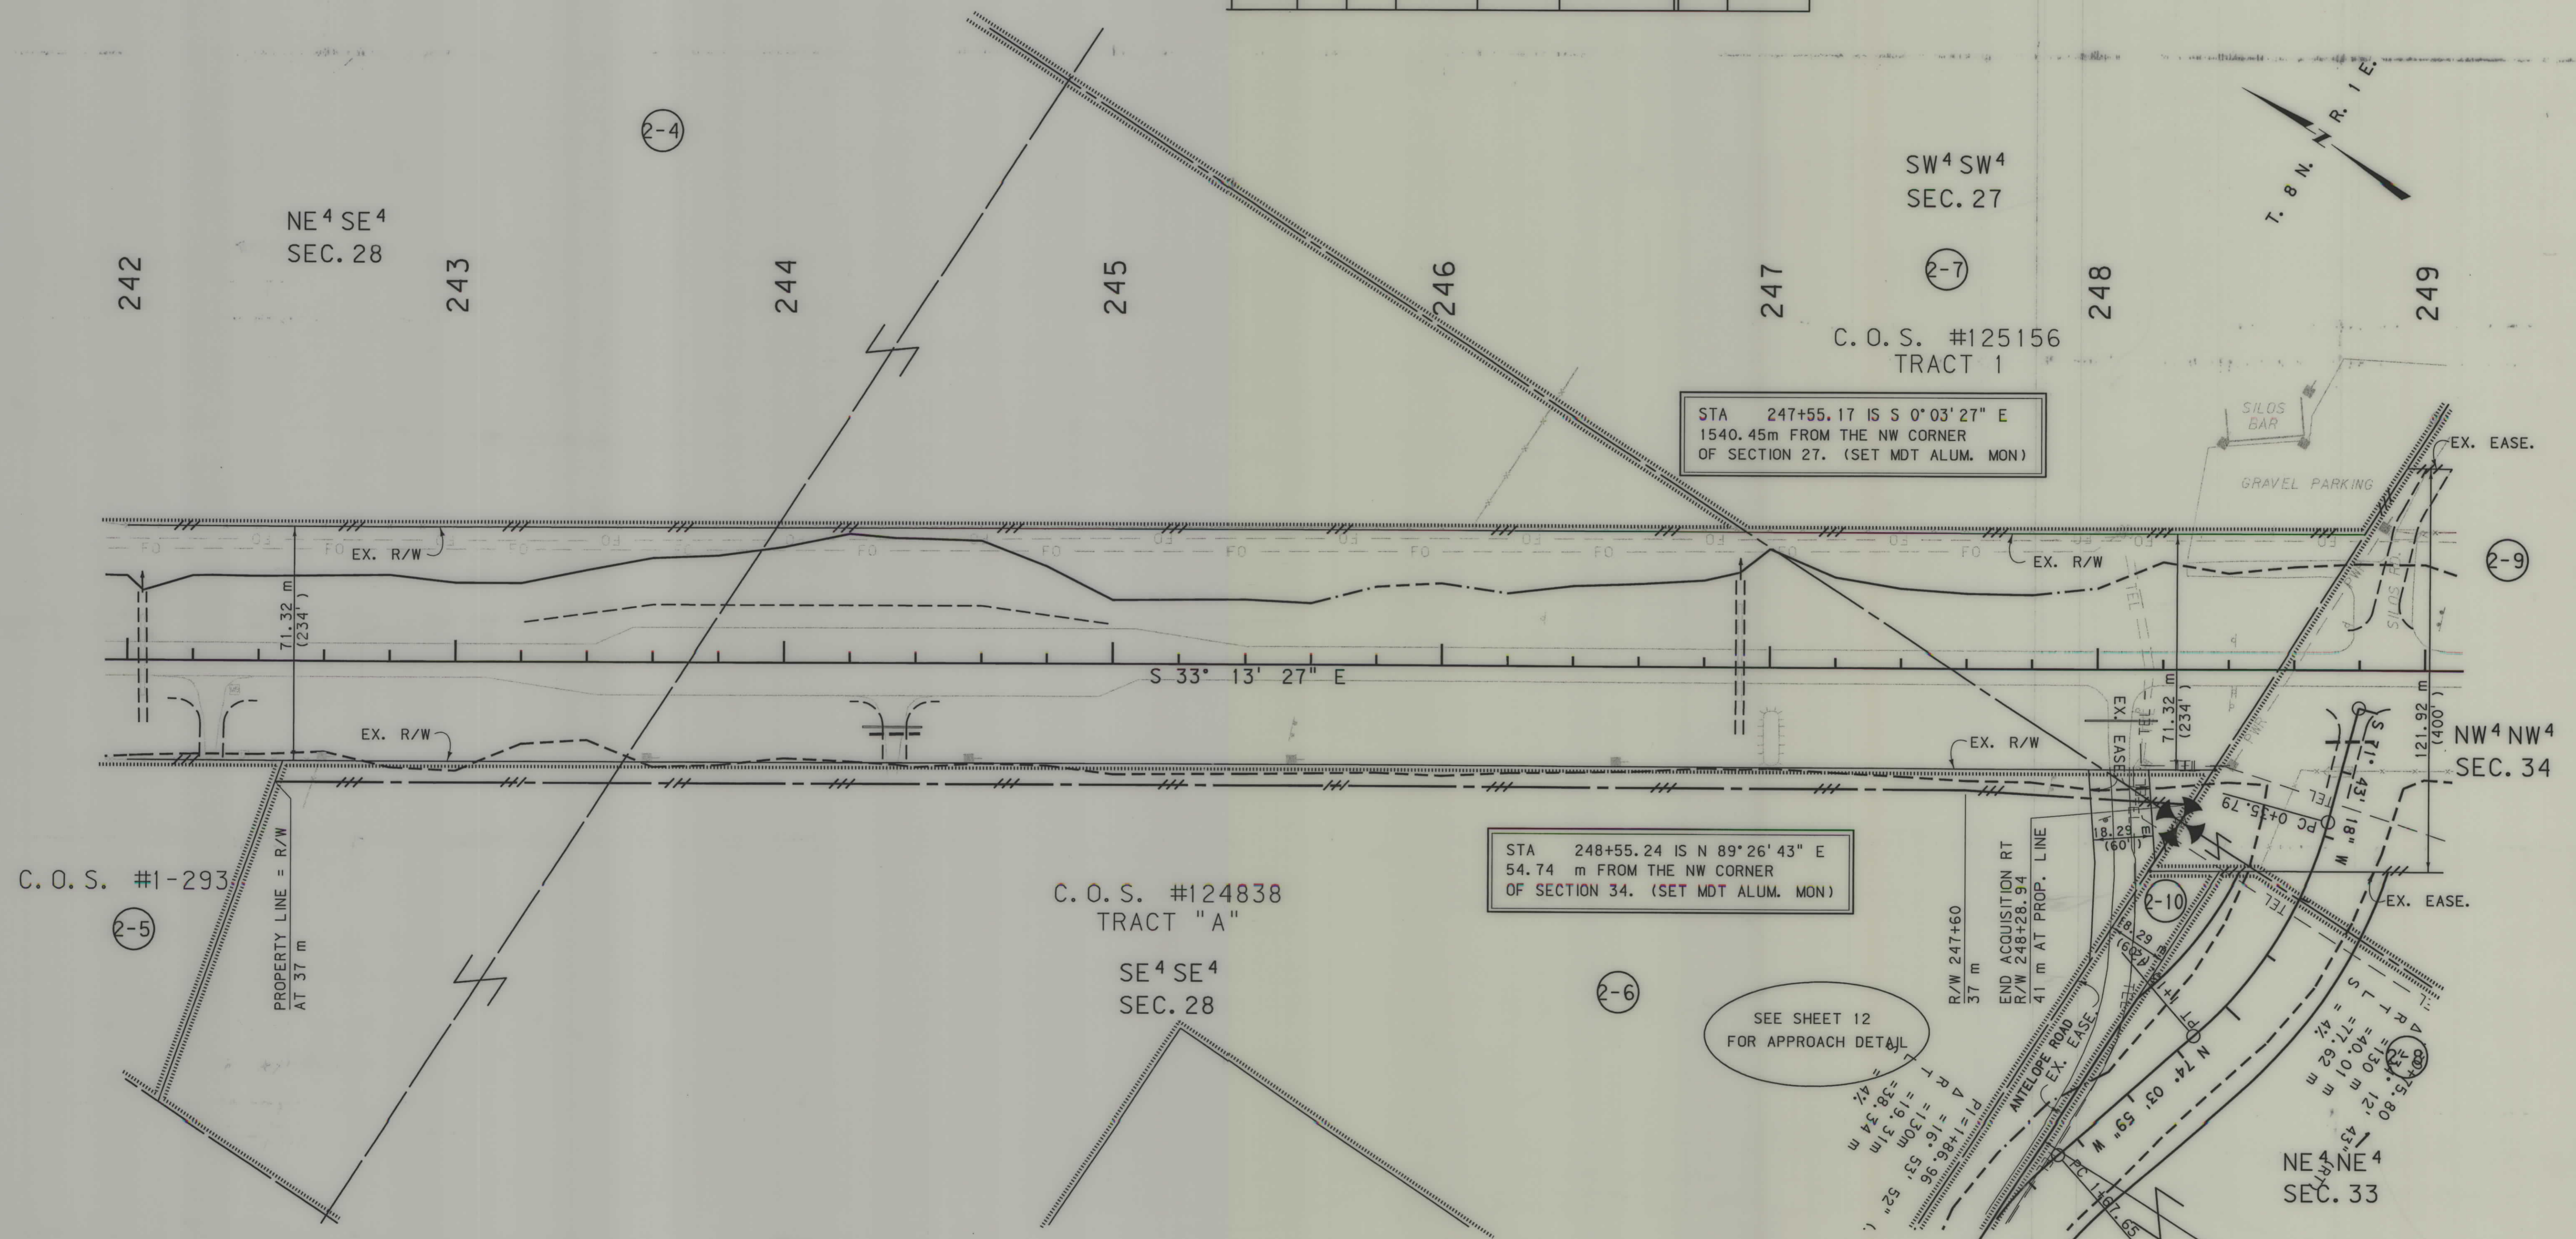

- NOTES: 1. ALL MEASUREMENTS ARE METRIC EXCEPT AS NOTED
2. THE PROPOSED R/W LINE WHERE A SPIRAL CURVE TRANSITION IS USED IS A CHORD RATHER THAN A CONCENTRIC CURVE.
3. THE ENGLISH AREAS ARE FOR INFORMATIONAL PURPOSES ONLY.
4. ALL STATIONS AND OFFSETS FOR R/W BREAKS ARE IN REFERENCE TO THE R/W BASELINE.

BACKSLOPE LIMITS INCLUDE ROUNDING
CONSTRUCTION LIMITS:

CUT SECTION
TOE OF FILL

TOP OF CUT
DITCH BOTTOM

FHWA/DOT APPROVAL 7/31/01

MAP REVISED 8/30/01 11/19/01 1/29/02

MONTANA
DEPARTMENT OF TRANSPORTATION

RIGHT OF WAY PLAN
BROADWATER COUNTY

SCALE 1" = 1000'

SEE SHEET NO. 2 FOR OWNERSHIP NAMES, ADDRESSES, AREAS, ETC.

[illegible]


(1) MOVABLE ROAD APPROACHES MAY BE RELOCATED BETWEEN THE SPECIFIED STATIONS AFTER THE INITIAL RECONSTRUCTION. A PERMIT MUST BE OBTAINED FROM THE MDOT OFFICE IN BUTTE.

(2) JOINT-USE ROAD APPROACH RELOCATIONS
"RESTRICTED".

STATE	RIGHT OF WAY ID.	SHEET	TOTAL
		NO.	SHEETS
MONTANA	NH-8-4(27)58	10	12

PROJECT NUMBER 3377-027

US 287 PASSING LANES
(NORTH OF SILOS SECTION)

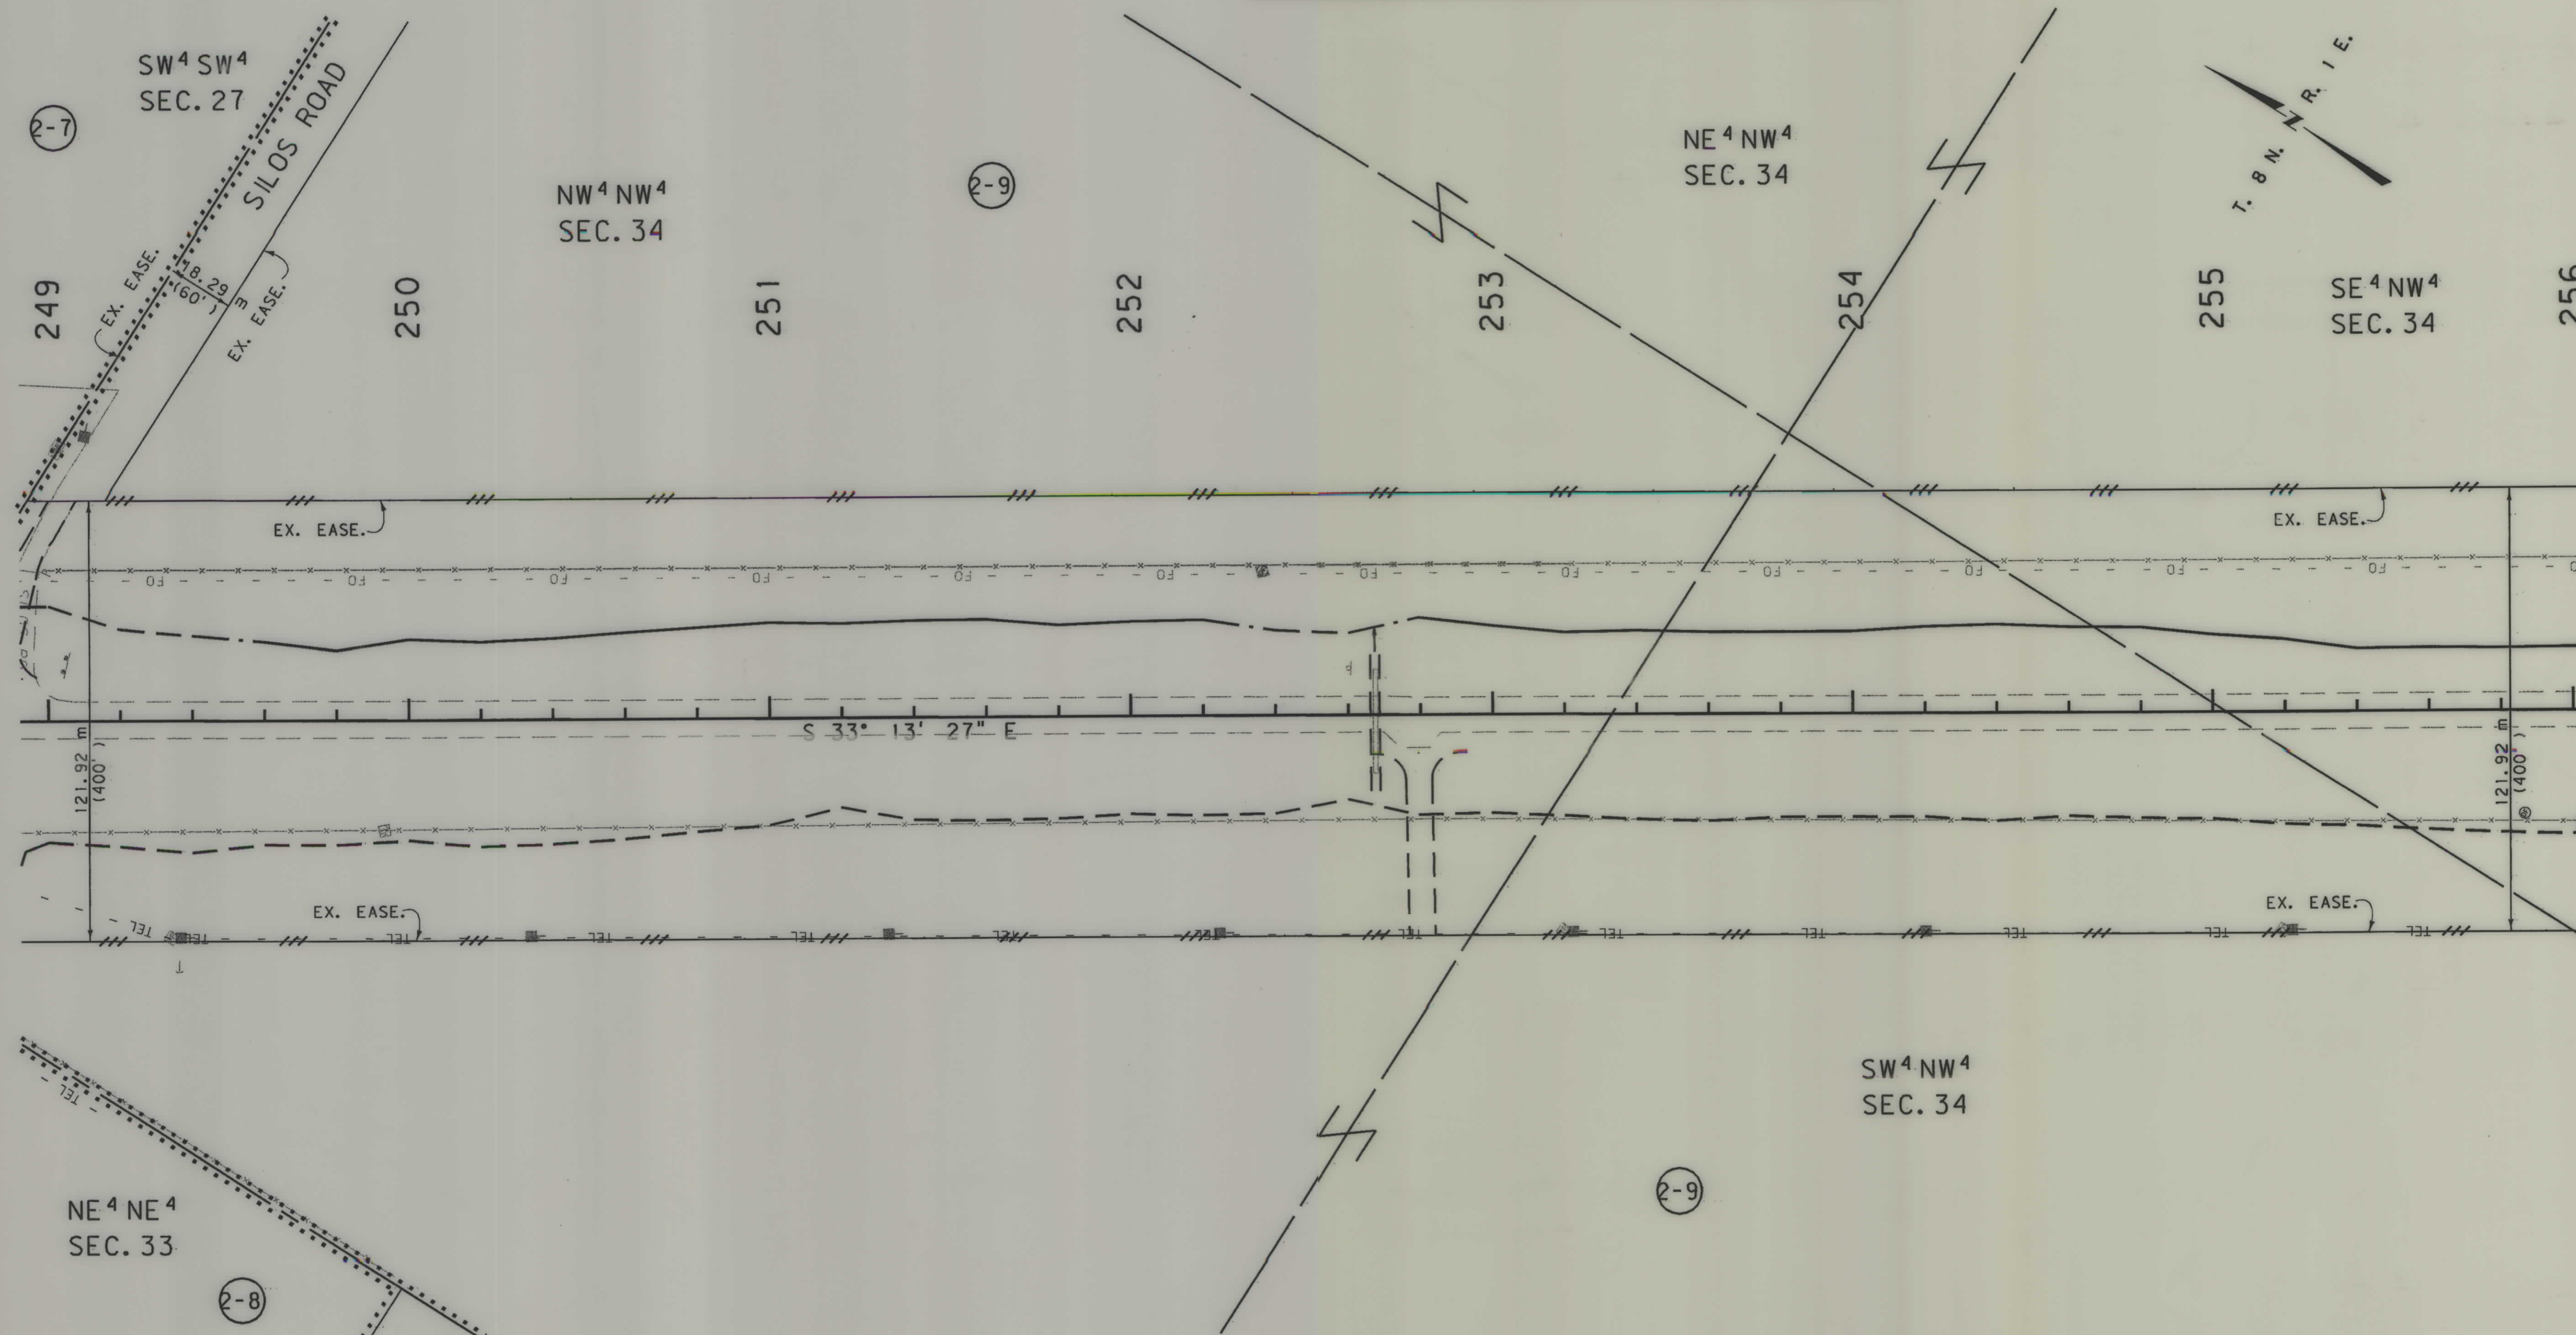

- NOTES: 1. ALL MEASUREMENTS ARE METRIC EXCEPT AS NOTED
2. THE PROPOSED R/W LINE WHERE A SPIRAL CURVE TRANSITION IS USED IS A CHORD RATHER THAN A CONCENTRIC CURVE.
3. THE ENGLISH AREAS ARE FOR INFORMATIONAL PURPOSES ONLY.
4. ALL STATIONS AND OFFSETS FOR R/W BREAKS ARE IN REFERENCE TO THE R/W BASELINE.

 
BACKSLOPE LIMITS INCLUDE ROUNDING
CONSTRUCTION LIMITS:

FHWA/DOT APPROVAL 7/31/01

MAP REVISED 8/30/01


MONTANA
DEPARTMENT OF TRANSPORTATION

RIGHT OF WAY PLAN
BROADWATER COUNTY
SCALE 1:1000



SEE SHEET NO. 2 FOR OWNERSHIP NAMES, ADDRESSES, AREAS, ETC.

STATE	RIGHT OF WAY ID.	SHEET NO.	TOTAL SHEETS
MONTANA	NH 8-4(27)58	11	12
PROJECT NUMBER 3377-027			
US 287 PASSING LANES (NORTH OF SILOS SECTION)			

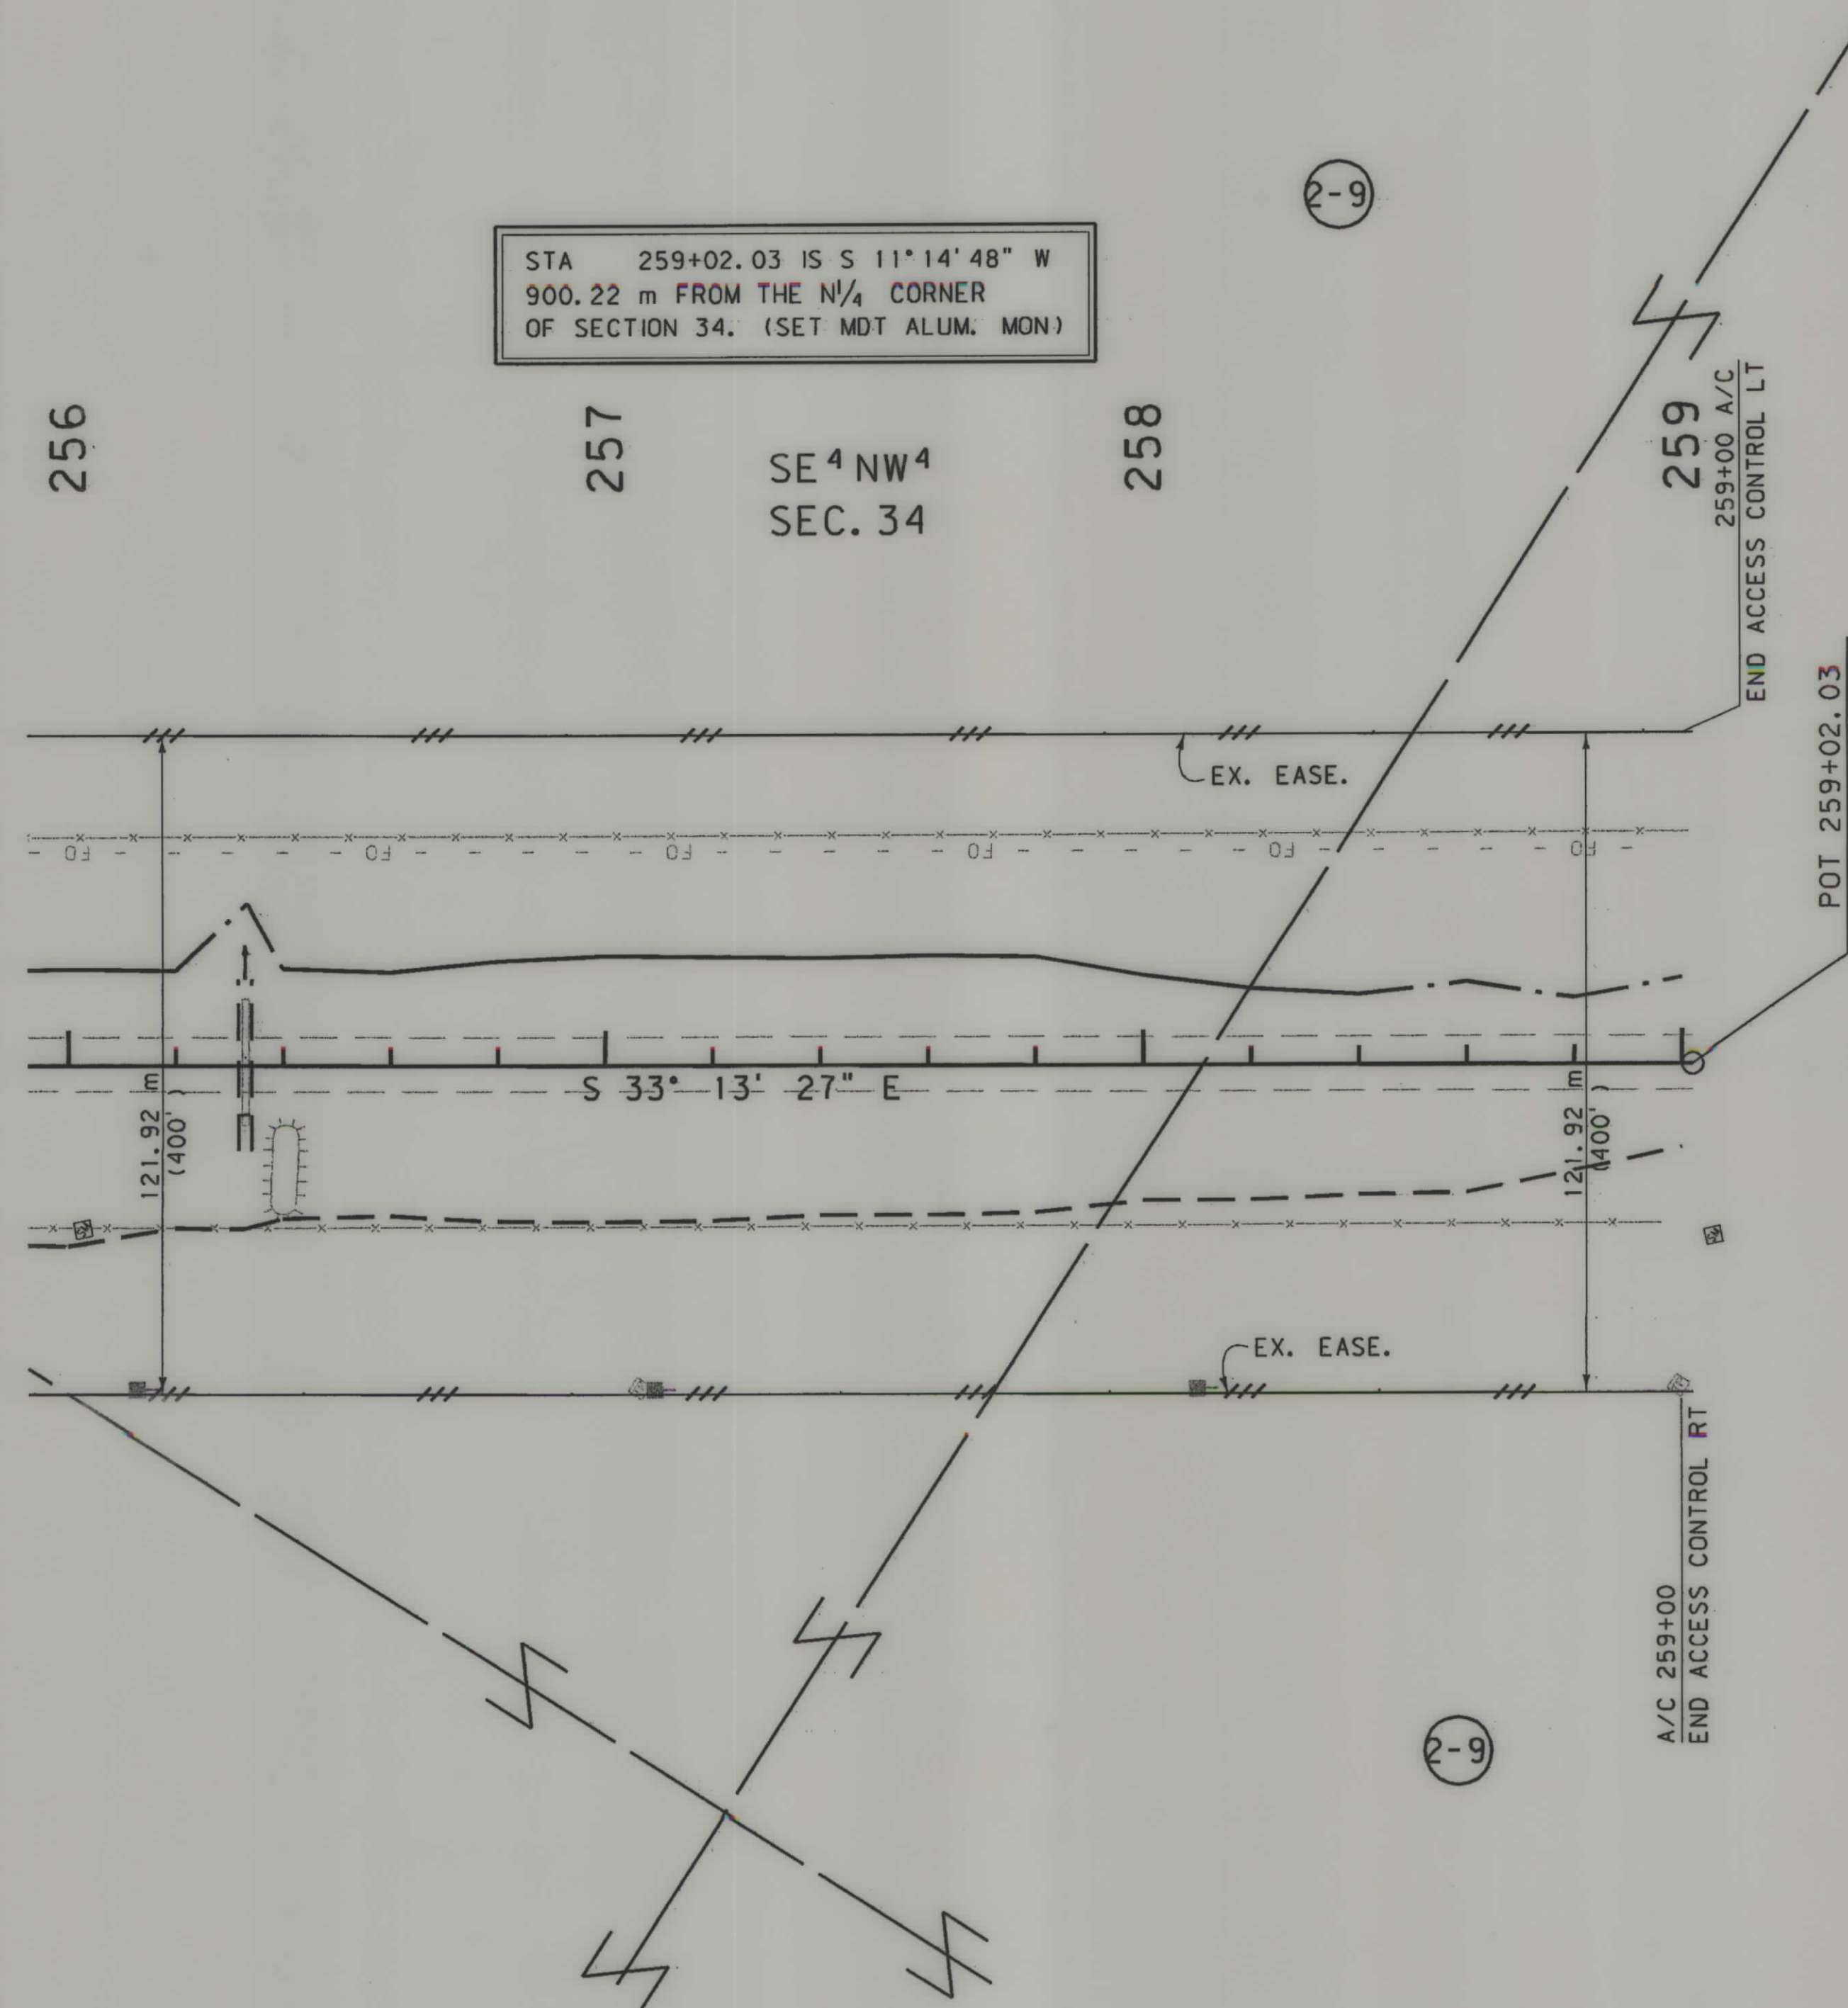


NE⁴SW⁴
SEC. 34

- NOTES: 1. ALL MEASUREMENTS ARE METRIC EXCEPT AS NOTED
2. THE PROPOSED R/W LINE WHERE A SPIRAL CURVE TRANSITION IS USED IS A CHORD RATHER THAN A CONCENTRIC CURVE.
3. THE ENGLISH AREAS ARE FOR INFORMATIONAL PURPOSES ONLY.
4. ALL STATIONS AND OFFSETS FOR R/W BREAKS ARE IN REFERENCE TO THE R/W BASELINE.

BACKSLOPE LIMITS INCLUDE ROUNDING	TOP OF CUT
CONSTRUCTION LIMITS:	CUT SECTION
	TOE OF FILL
	DITCH BOTTOM
FHWA/DOT APPROVAL	7/31/01
MAP REVISED	8/30/01

MONTANA
DEPARTMENT OF TRANSPORTATION

 RIGHT OF WAY PLAN
BROADWATER COUNTY
SCALE 1:1000



SEE SHEET NO. 2 FOR OWNERSHIP NAMES, ADDRESSES, AREAS, ETC.


[illegible]

(1) MOVABLE ROAD APPROACHES MAY BE RELOCATED BETWEEN THE SPECIFIED STATIONS AFTER THE INITIAL RECONSTRUCTION. A PERMIT MUST BE OBTAINED FROM THE MDOT OFFICE IN

(2) JOINT-USE ROAD APPROACH RELOCATIONS "RESTRICTED".

STATE	RIGHT OF WAY ID.	SHEET	TOTAL
		NO.	SHEETS
MONTANA	NH 8-4 (27) 58	12	12
PROJECT NUMBER 3377-027			

US 287 PASSING LANES
(NORTH OF SILOS SECTION)

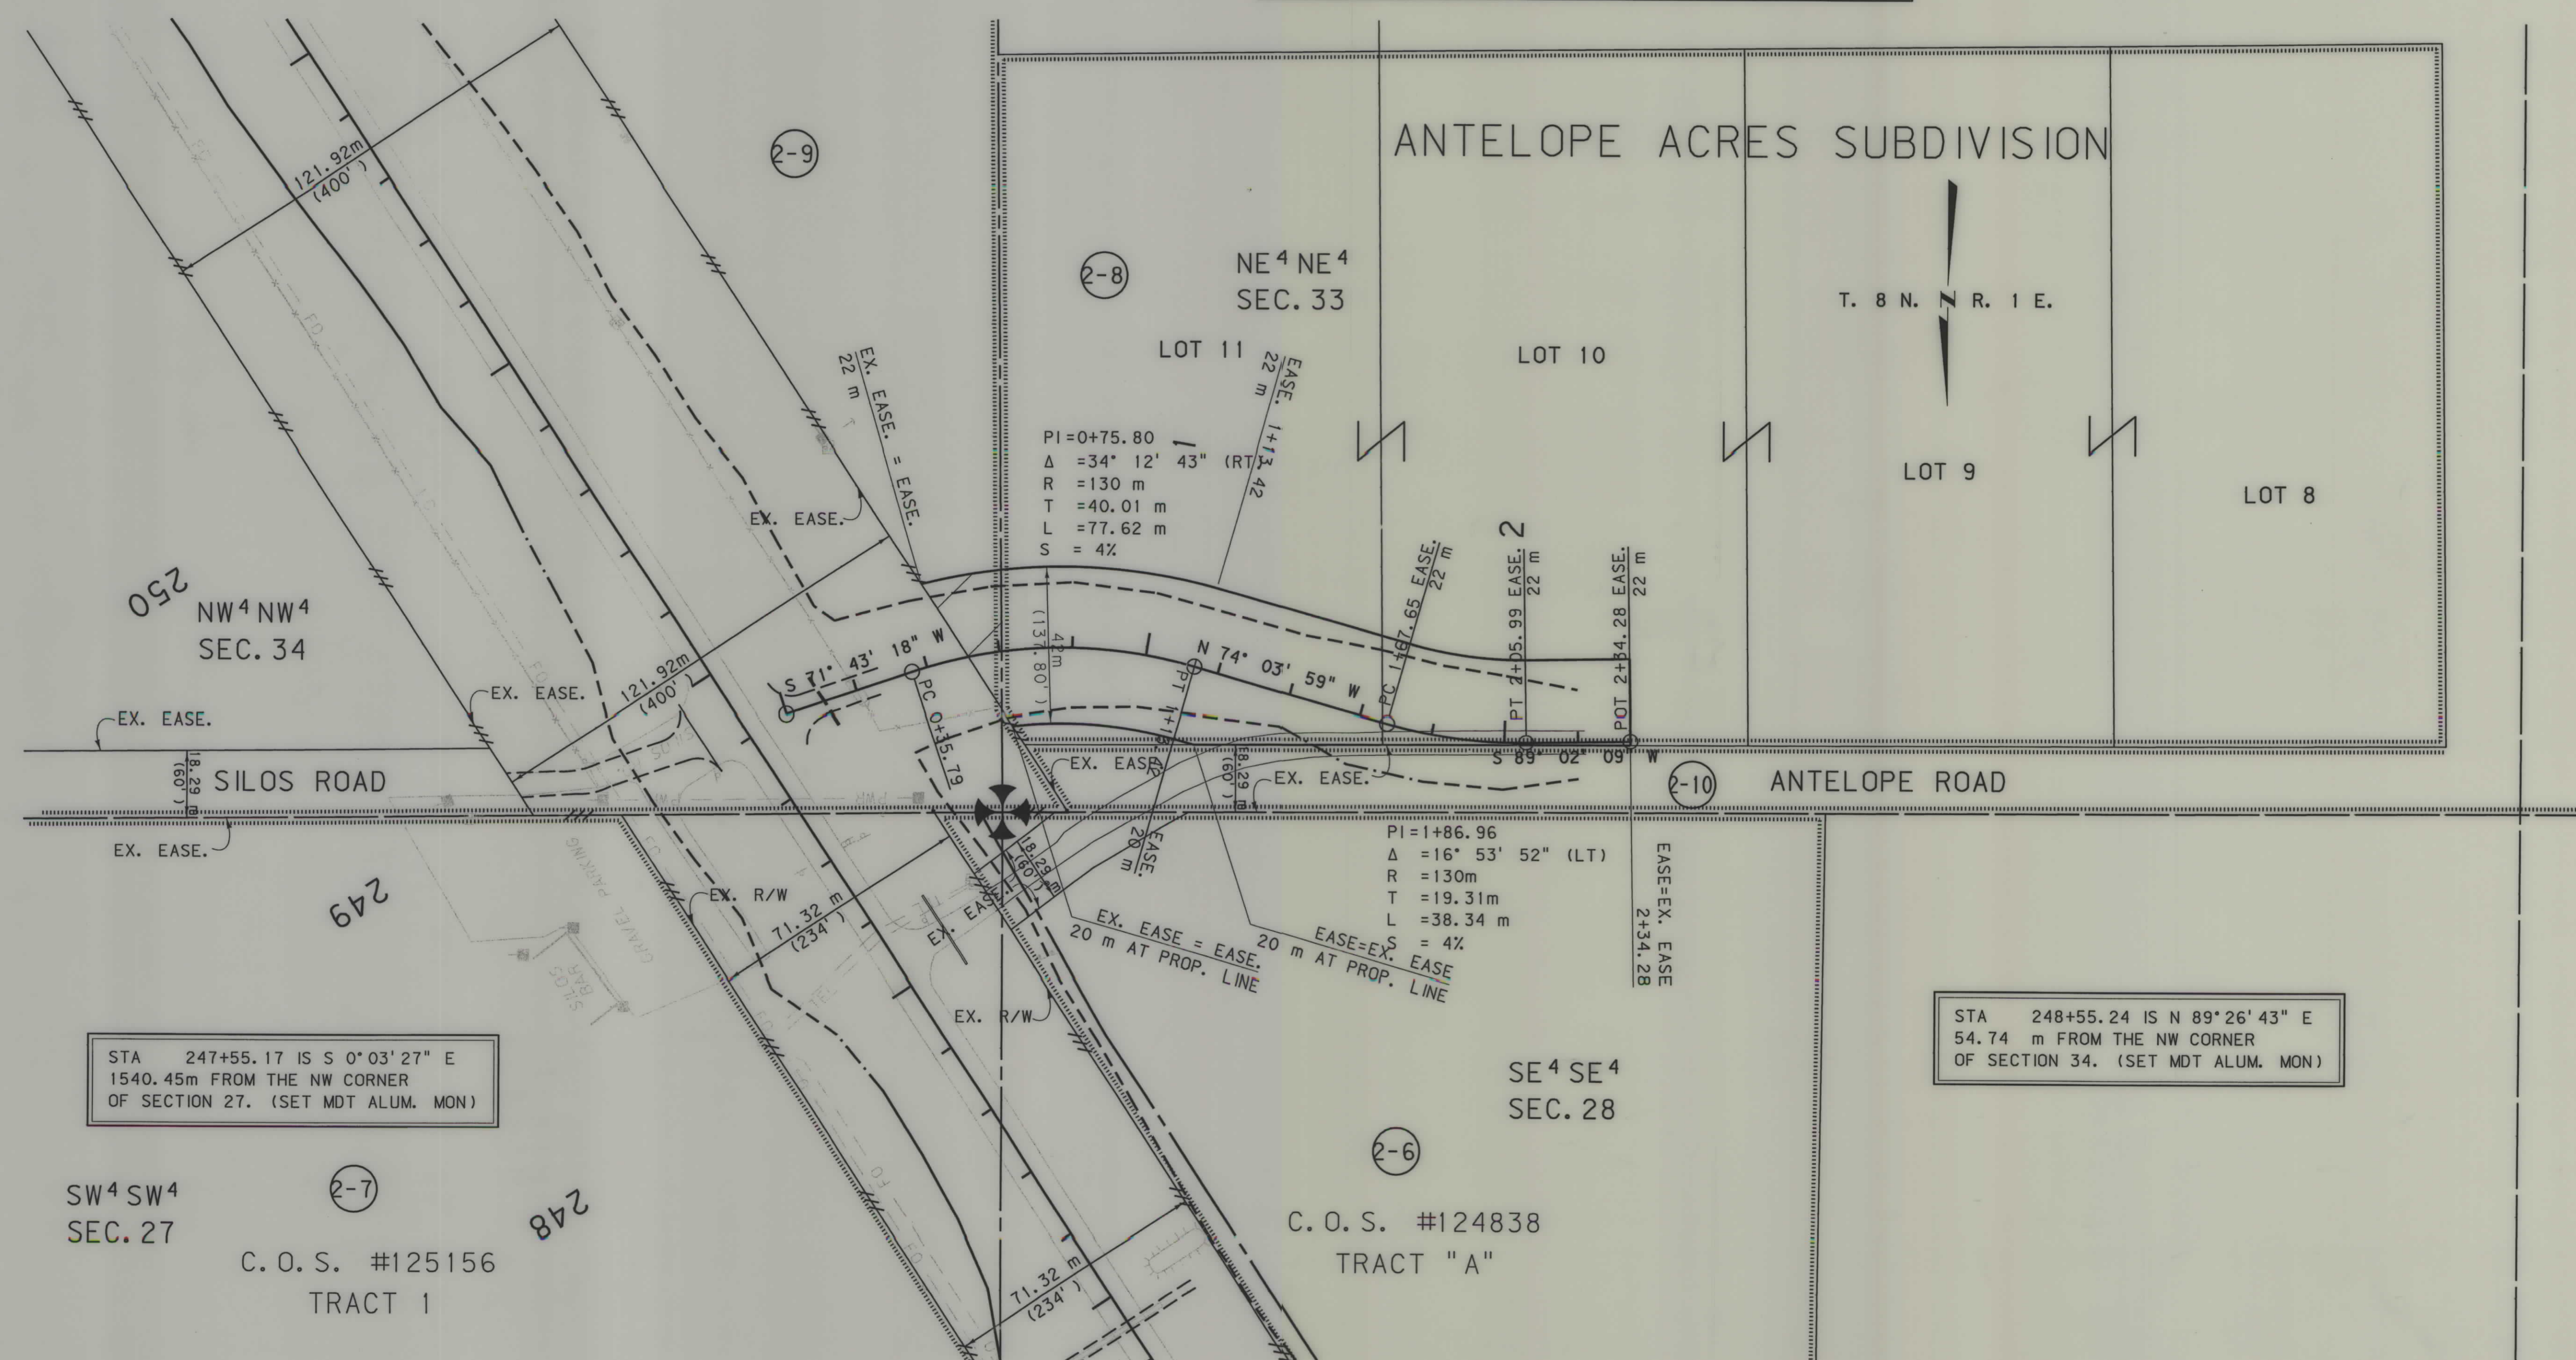

- NOTES: 1. ALL MEASUREMENTS ARE METRIC EXCEPT AS NOTED
2. THE PROPOSED R/W LINE WHERE A SPIRAL CURVE TRANSITION IS USED IS A CHORD RATHER THAN A CONCENTRIC CURVE.
3. THE ENGLISH AREAS ARE FOR INFORMATIONAL PURPOSES ONLY.
4. ALL STATIONS AND OFFSETS FOR R/W BREAKS ARE IN REFERENCE TO THE R/W BASELINE.

BACKSLOPE LIMITS INCLUDE ROUNDING		
CONSTRUCTION LIMITS:		
FHWA/DOT APPROVAL _____		7/31/01
MAP REVISED 8/30/01		12/7/01

MONTANA
DEPARTMENT OF TRANSPORTATION

RIGHT OF WAY PLAN
BROADWATER COUNTY
SCALE 1:1000

