


PLANS

NOT

TO

SCALE

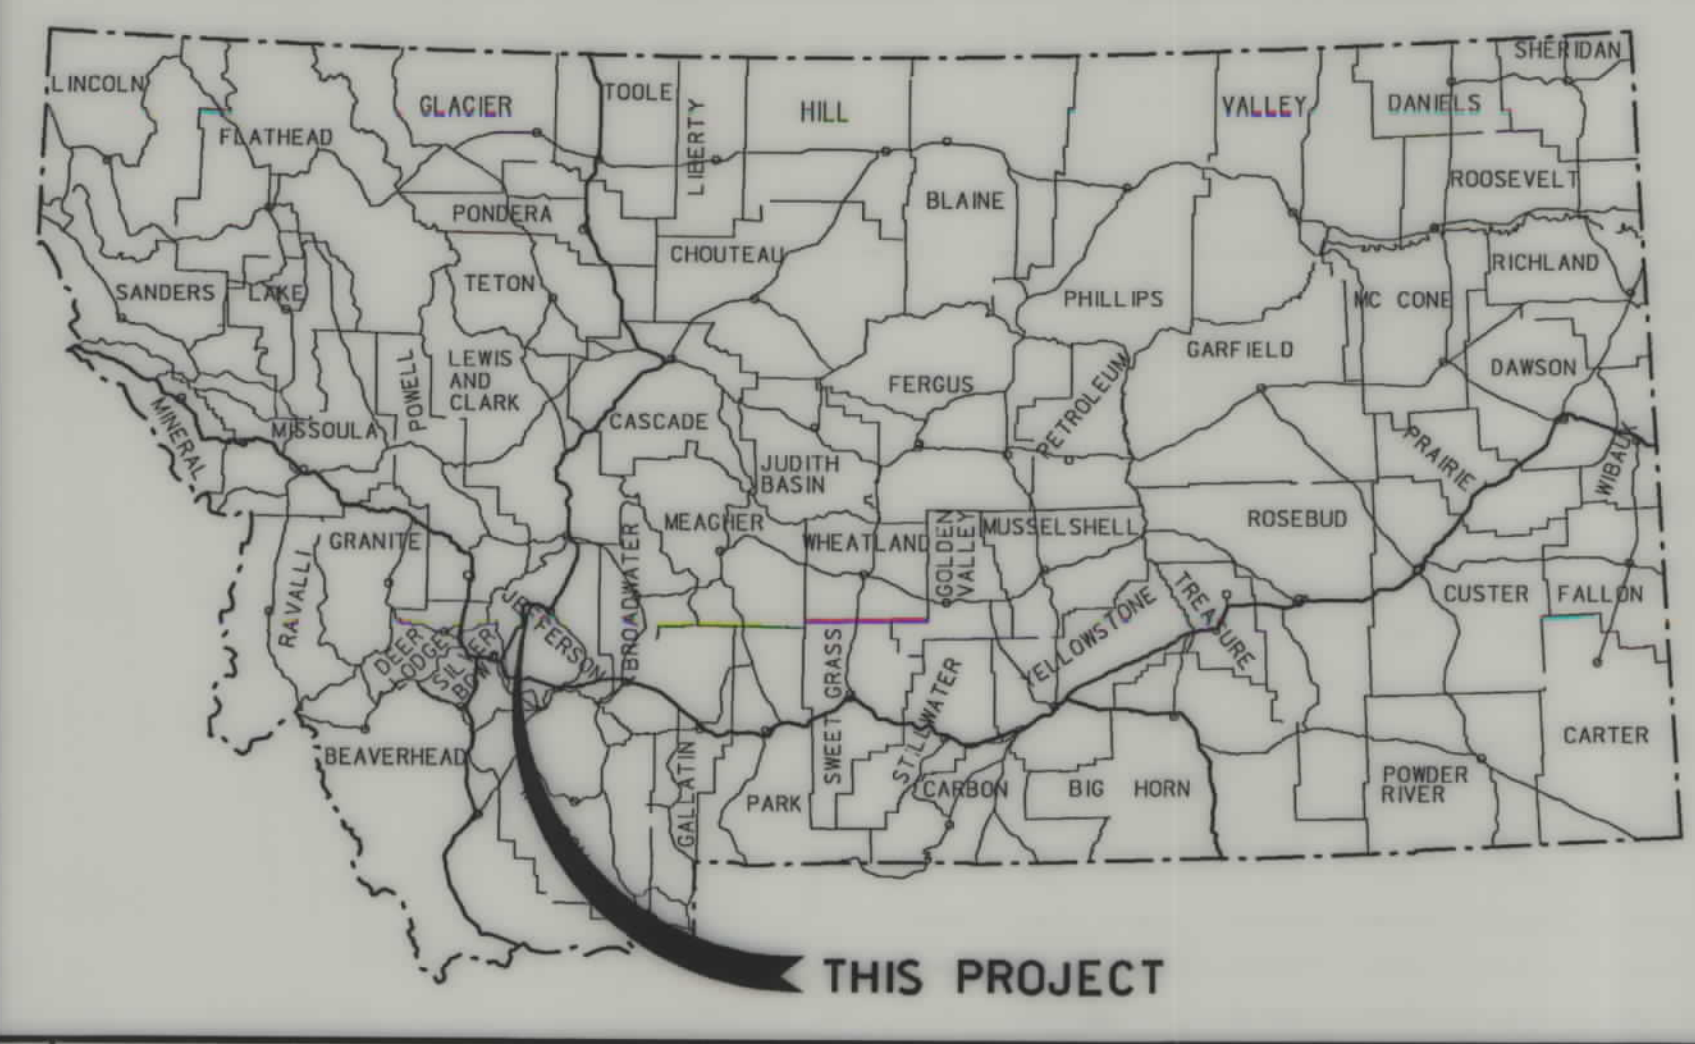

MONTANA DEPARTMENT OF TRANSPORTATION

STATE	RIGHT OF WAY ID.	SHEET NO.	TOTAL SHEETS
MONTANA	BR 9022(25)	1	4
PROJECT NUMBER 3981-025			
BOULDER R - 6 KM E OF BASIN			

RIGHT OF WAY PLAN OF FEDERAL AID PROJECT BR 9022(25) BOULDER R - 6 KM E OF BASIN JEFFERSON COUNTY


0.4 Kilometers

CONVENTIONAL SIGNS	
PROPOSED RIGHT OF WAY LINE	---
EXISTING RIGHT OF WAY LINE	---
RAILROAD RIGHT OF WAY LINE	---
CENTERLINE (C) OR PROJECTED LINE	---
STK'D CENTERLINE	---
SECTION LINE	---
OWNERSHIP BOUNDARY	---
FULL ACCESS CONTROL	AG AG
LIMITED ACCESS CONTROL	/// ///
EXISTING ACCESS CONTROL	/// ///
PRESENT TRAVELED WAY (P.T.W.)	---
FENCE LINE	---
EXISTING GUARDRAIL	- - -
PROPOSED GUARDRAIL	- - -
GATE IN FENCE	---
CATTLE GUARD: EXIST. - PROPOSED	---
SECTION CORNER	FOUND UNFOUND
1/4 SECTION CORNER	---
CLOSING CORNER	---
MEANDER CORNER	---
CENTER OF SECTION	---
RIGHT OF WAY MONUMENT	---
PROPERTY CORNER PIN	---
POWER POLE IN PLACE	---
TELEPHONE POLE IN PLACE	---
TELEGRAPH POLE IN PLACE	---
LIGHT POLE	---
PROPOSED CULVERT	---
EXISTING CULVERT	---
OUTLET DITCH	---
INLET DITCH	---
EXISTING DITCH	---
CHANNEL CHANGES	CH. CH. 20
DITCH BLOCK	---
RIPRAP	---
BRIDGES	---
RAILROADS	---
PARCEL NUMBERS	---
APPROACH: EXIST.- PROPOSED	---

ASSOCIATED PROJECT ID.
BR 9022(21) PE

RELATED PROJECTS
I-IG 15-3(29)157 FAP 242-D

FHWAMDT APPROVAL	6/28/01
MAP REVISED	

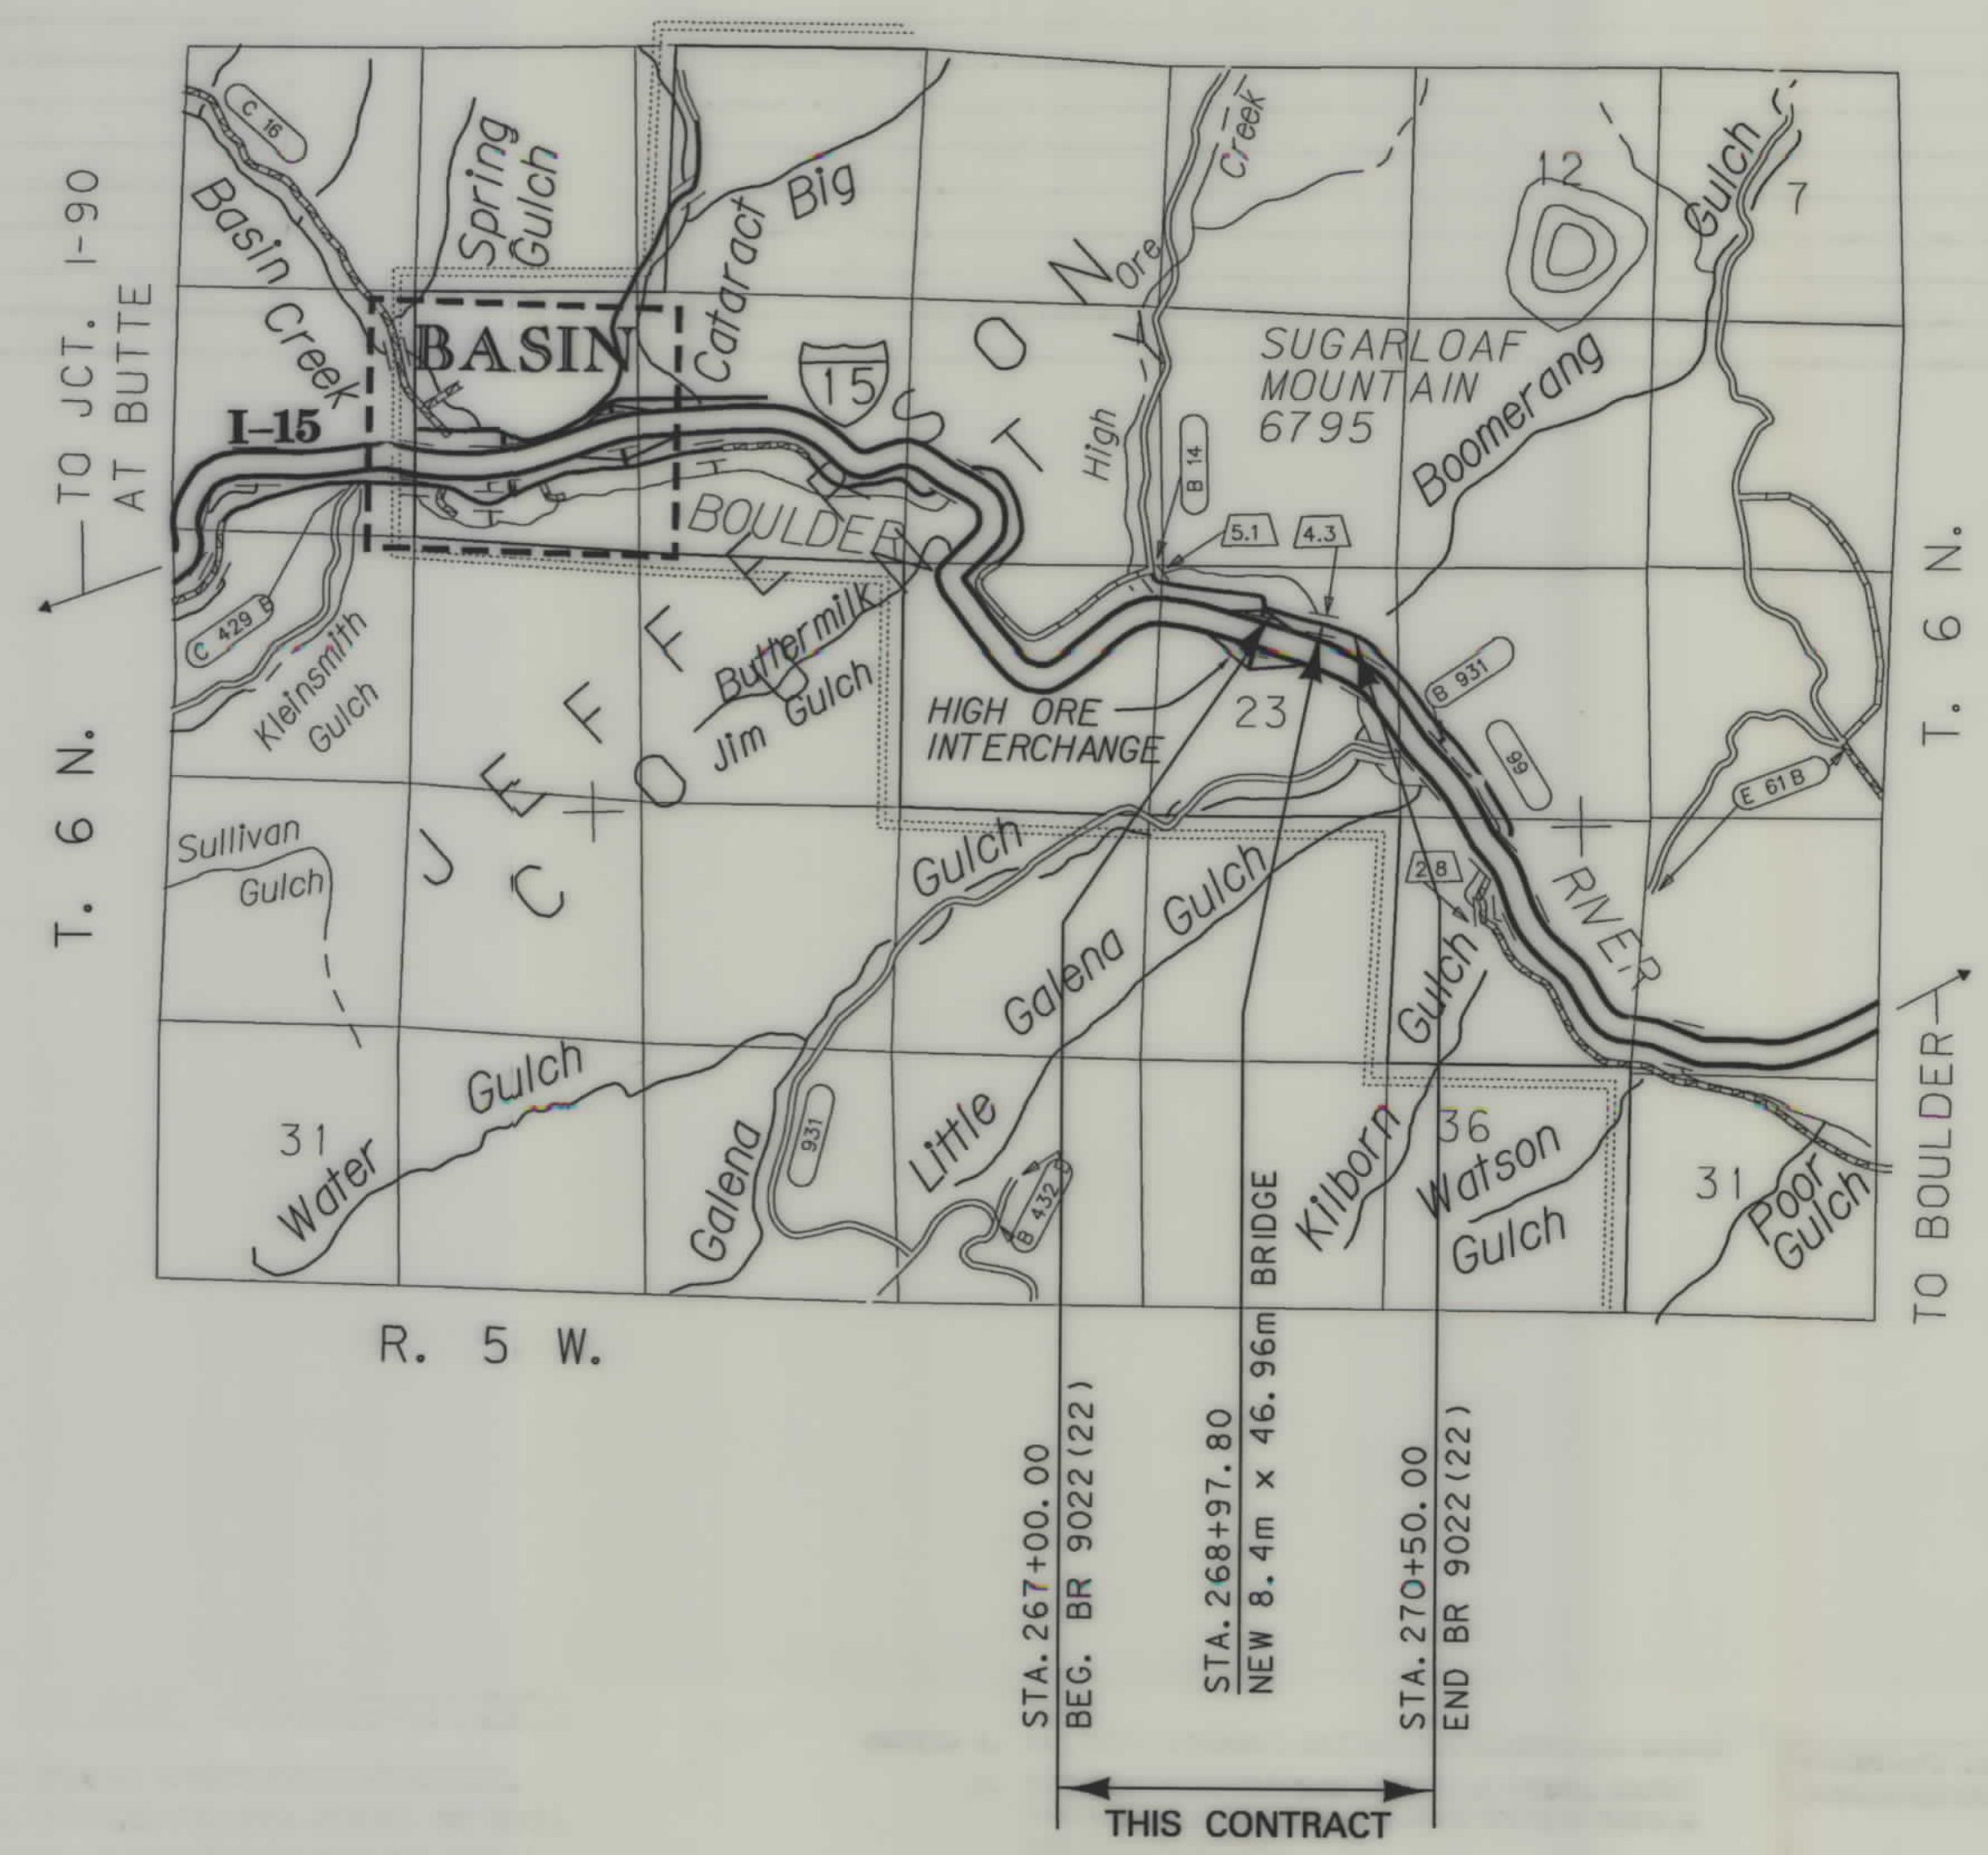

SEE SHEET NO. 4 FOR OWNERSHIP NAMES, ADDRESSES, AREAS, ETC.

GRID STATE PLANE COORDINATES

THIS IS A STATE PLANE COORDINATE PROJECT. ALL DIMENSIONS, DISTANCES AND AREAS ON THIS PROJECT ARE GRID, EXCEPT FOR THE EXISTING R/W WIDTH, WHICH IS RECORD. THE COMBINATION SCALE FACTOR IS 0.99923935

NOTES: 1. ALL MEASUREMENTS ARE METRIC EXCEPT AS NOTED

ALL FILES ARE LOCATED ON THE CADD SERVER
IN THE RO DIRECTORY, UNDER PROJECT: 3981

[illegible]


THIS IS A STATE PLANE COORDINATE PROJECT.
ALL DIMENSIONS, DISTANCES AND AREAS ON THIS
PROJECT ARE GRID, EXCEPT FOR THE EXISTING
R/W WIDTH, WHICH IS RECORD. THE COMBINATION
SCALE FACTOR IS 0.99923935

MAP REVISED

RIGHT OF WAY PLAN
JEFFERSON COUNTY

CONTROL DIAGRAM

STATE	RIGHT OF WAY ID.	SHEET NO.	TOTAL SHEETS
MONTANA	BR 9022 (25)	3	4
PROJECT NUMBER 3981-025			
BOULDER R - 6 KM E OF BASIN			

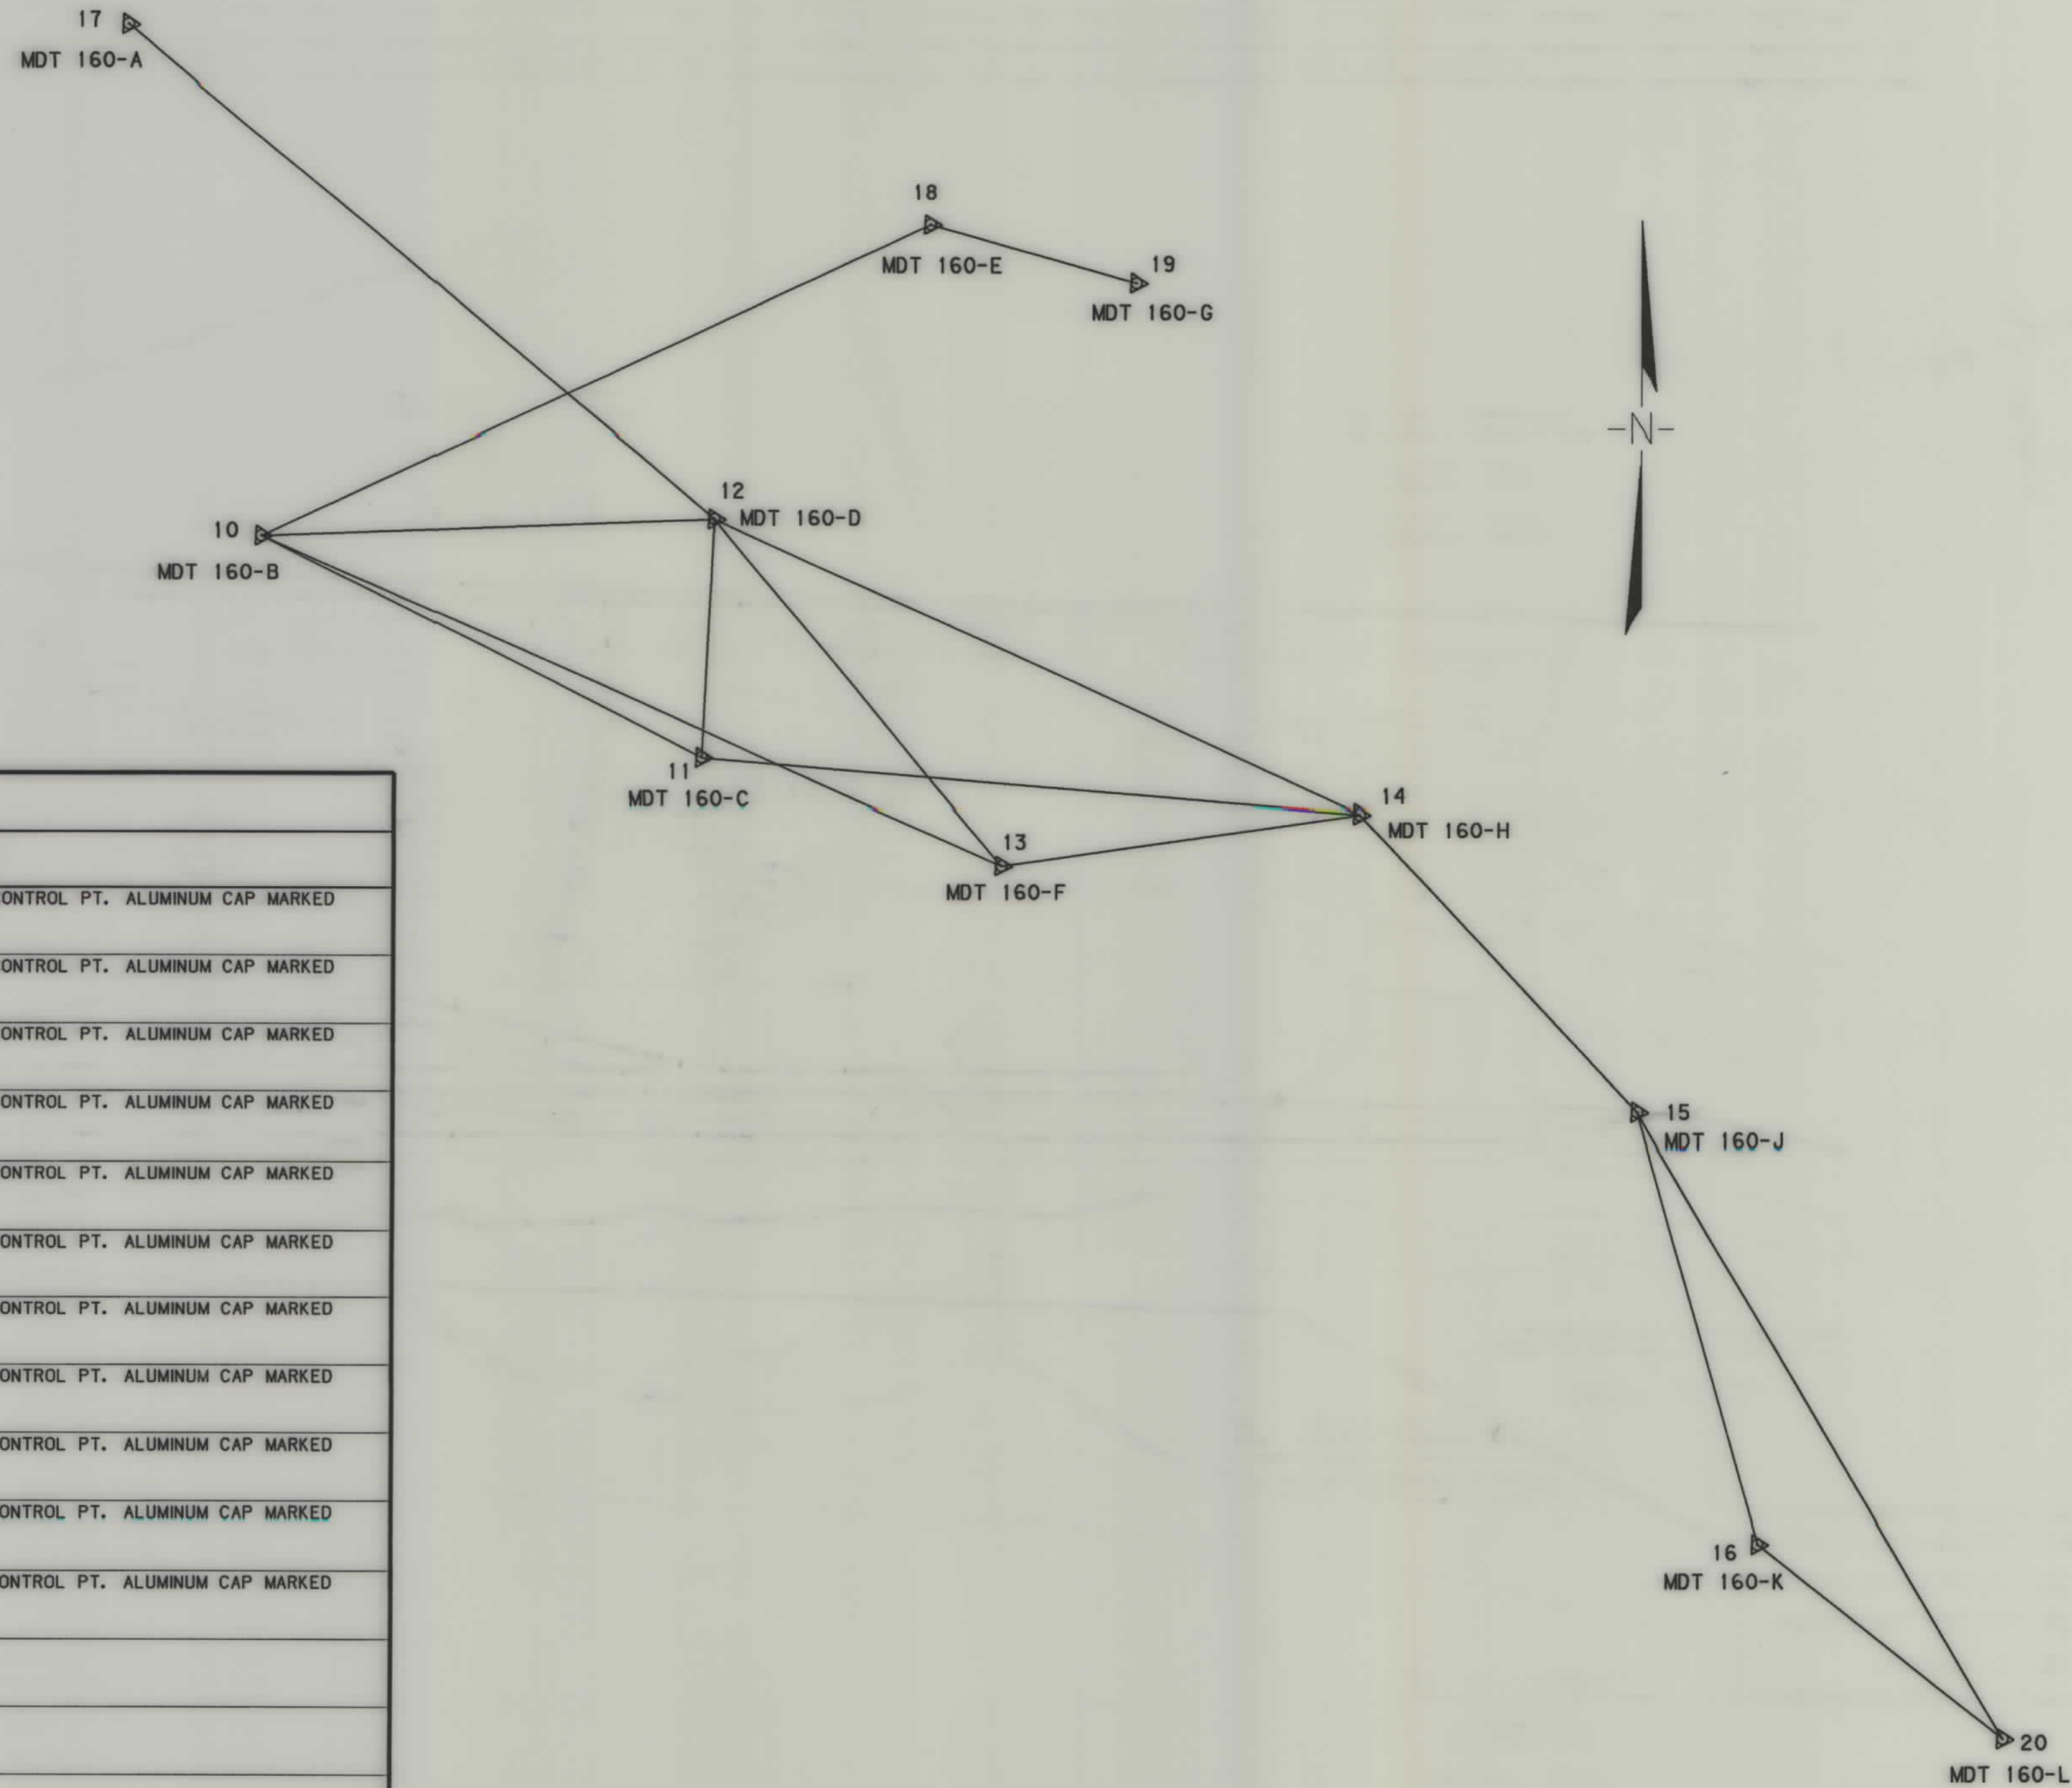

CONTROL ABSTRACT

POINT NUMBER	NORTHING	EASTING	STATION ELEVATION	GROUND ELEVATION	LOCATION DESCRIPTION
10	226927.652	392583.836	1558.235		SET A 2cm X 60cm REBAR WITH 50mm M.D.O.H. HORIZ. CONTROL PT. ALUMINUM CAP MARKED 160-B, 1999
11	226846.999	392744.842	1555.636		SET A 2cm X 60cm REBAR WITH 50mm M.D.O.H. HORIZ. CONTROL PT. ALUMINUM CAP MARKED 160-C, 1999
12	226933.926	392749.234	1550.671		SET A 2cm X 60cm REBAR WITH 50mm M.D.O.H. HORIZ. CONTROL PT. ALUMINUM CAP MARKED 160-D, 1999
13	226808.534	392854.822	1552.822		SET A 2cm X 60cm REBAR WITH 50mm M.D.O.H. HORIZ. CONTROL PT. ALUMINUM CAP MARKED 160-F, 1999
14	226827.829	392985.997	1548.009		SET A 2cm X 60cm REBAR WITH 50mm M.D.O.H. HORIZ. CONTROL PT. ALUMINUM CAP MARKED 160-H, 1999
15	226719.806	393088.175	1546.080		SET A 2cm X 60cm REBAR WITH 50mm M.D.O.H. HORIZ. CONTROL PT. ALUMINUM CAP MARKED 160-J, 1999
16	226563.889	393132.894	1545.026		SET A 2cm X 60cm REBAR WITH 50mm M.D.O.H. HORIZ. CONTROL PT. ALUMINUM CAP MARKED 160-K, 1999
17	227112.162	392534.908	1549.489		SET A 2cm X 60cm REBAR WITH 50mm M.D.O.H. HORIZ. CONTROL PT. ALUMINUM CAP MARKED 160-A, 1999
18	227040.094	392828.172	1559.767		SET A 2cm X 60cm REBAR WITH 50mm M.D.O.H. HORIZ. CONTROL PT. ALUMINUM CAP MARKED 160-E, 1999
19	227019.216	392903.706	1559.891		SET A 2cm X 60cm REBAR WITH 50mm M.D.O.H. HORIZ. CONTROL PT. ALUMINUM CAP MARKED 160-G, 1999
20	226493.445	393223.186	1545.615		SET A 2cm X 60cm REBAR WITH 50mm M.D.O.H. HORIZ. CONTROL PT. ALUMINUM CAP MARKED 160-L, 1999

GRID STATE PLANE COORDINATES

THIS IS A STATE PLANE COORDINATE PROJECT.
ALL DIMENSIONS, DISTANCES AND AREAS ON THIS
PROJECT ARE GRID, EXCEPT FOR THE EXISTING
R/W WIDTH, WHICH IS RECORD. THE COMBINATION
SCALE FACTOR IS 0.99923935

- NOTES: 1. ALL MEASUREMENTS ARE METRIC EXCEPT AS NOTED
2. THE PROPOSED R/W LINE WHERE A SPIRAL CURVE TRANSITION IS USED IS A CHORD RATHER THAN A CONCENTRIC CURVE.
3. THE ENGLISH AREAS ARE FOR INFORMATIONAL PURPOSES ONLY.
4. ALL STATIONS AND OFFSETS FOR R/W BREAKS ARE IN REFERENCE TO THE R/W BASELINE.

BACKSLOPE LIMITS INCLUDE ROUNDING	TOP OF CUT
CONSTRUCTION LIMITS: CUT SECTION TOE OF FILL	DITCH BOTTOM
FHWA/DOT APPROVAL	6/28/01
MAP REVISED	

MONTANA
DEPARTMENT OF TRANSPORTATION
RIGHT OF WAY PLAN
JEFFERSON COUNTY





RDROW

3981001.rdw
07/10/01
02:08:17 PM
U4059

OWNERSHIP																			
PARCEL	NAME	ADDRESS	TOTAL	AREA	GROSS R/W AREA		EX. EASE. AREA		NET AREA		REMAINDER				CONST. PMT. AREA		EASE. AREA		SHEET NO.
			METRIC	ENGLISH	METRIC	ENGLISH	METRIC	ENGLISH	METRIC	ENGLISH	LEFT		RIGHT		METRIC	ENGLISH	METRIC	ENGLISH	
											METRIC	ENGLISH	METRIC	ENGLISH					
1	HAROLD J. GIULIO & DOLLY M. GIULIO	5100 S. WARREN AVE., TRLR. 1, BUTTE, MONTANA 59701	4.399 ha	10.87 AC	0.131 ha	0.32 AC			0.131 ha	0.32 AC	4.268 ha	10.55 AC			0.062 ha	0.15 AC			4
2	SANDRA L. SPENCE	P.O. BOX 49, BOULDER, MONTANA 59632	0.955 ha	2.36 AC	0.025 ha	0.06 AC			0.025 ha	0.06 AC	0.930 ha	2.30 AC			0.053 ha	0.13 AC			4
3	DAVID M. WHALEY & SHARON LEE WHALEY	P.O. BOX 868, BOULDER, MONTANA 59632	1.267 ha	3.13 AC	0.074 ha	0.18 AC			0.074 ha	0.18 AC	1.193 ha	2.95 AC			0.012 ha	0.03 AC			4
4	BURLINGTON NORTHERN RAILROAD COMPANY				0.016 ha	0.04 AC			0.016 ha	0.04 AC					0.049 ha	0.12 AC			4

STATE	RIGHT OF WAY ID.	SHEET NO.	TOTAL SHEETS
MONTANA	BR 9022 (25)	4	4
PROJECT NUMBER 3981 (25)			
BOULDER R - 6 KM E OF BASIN			

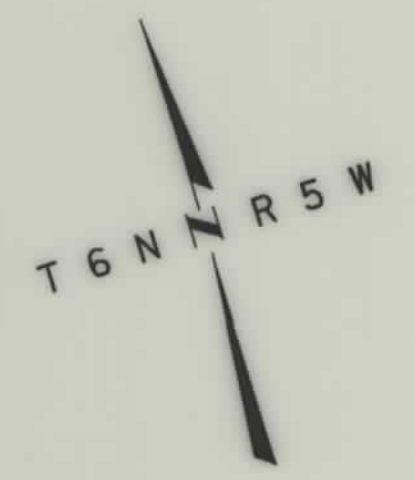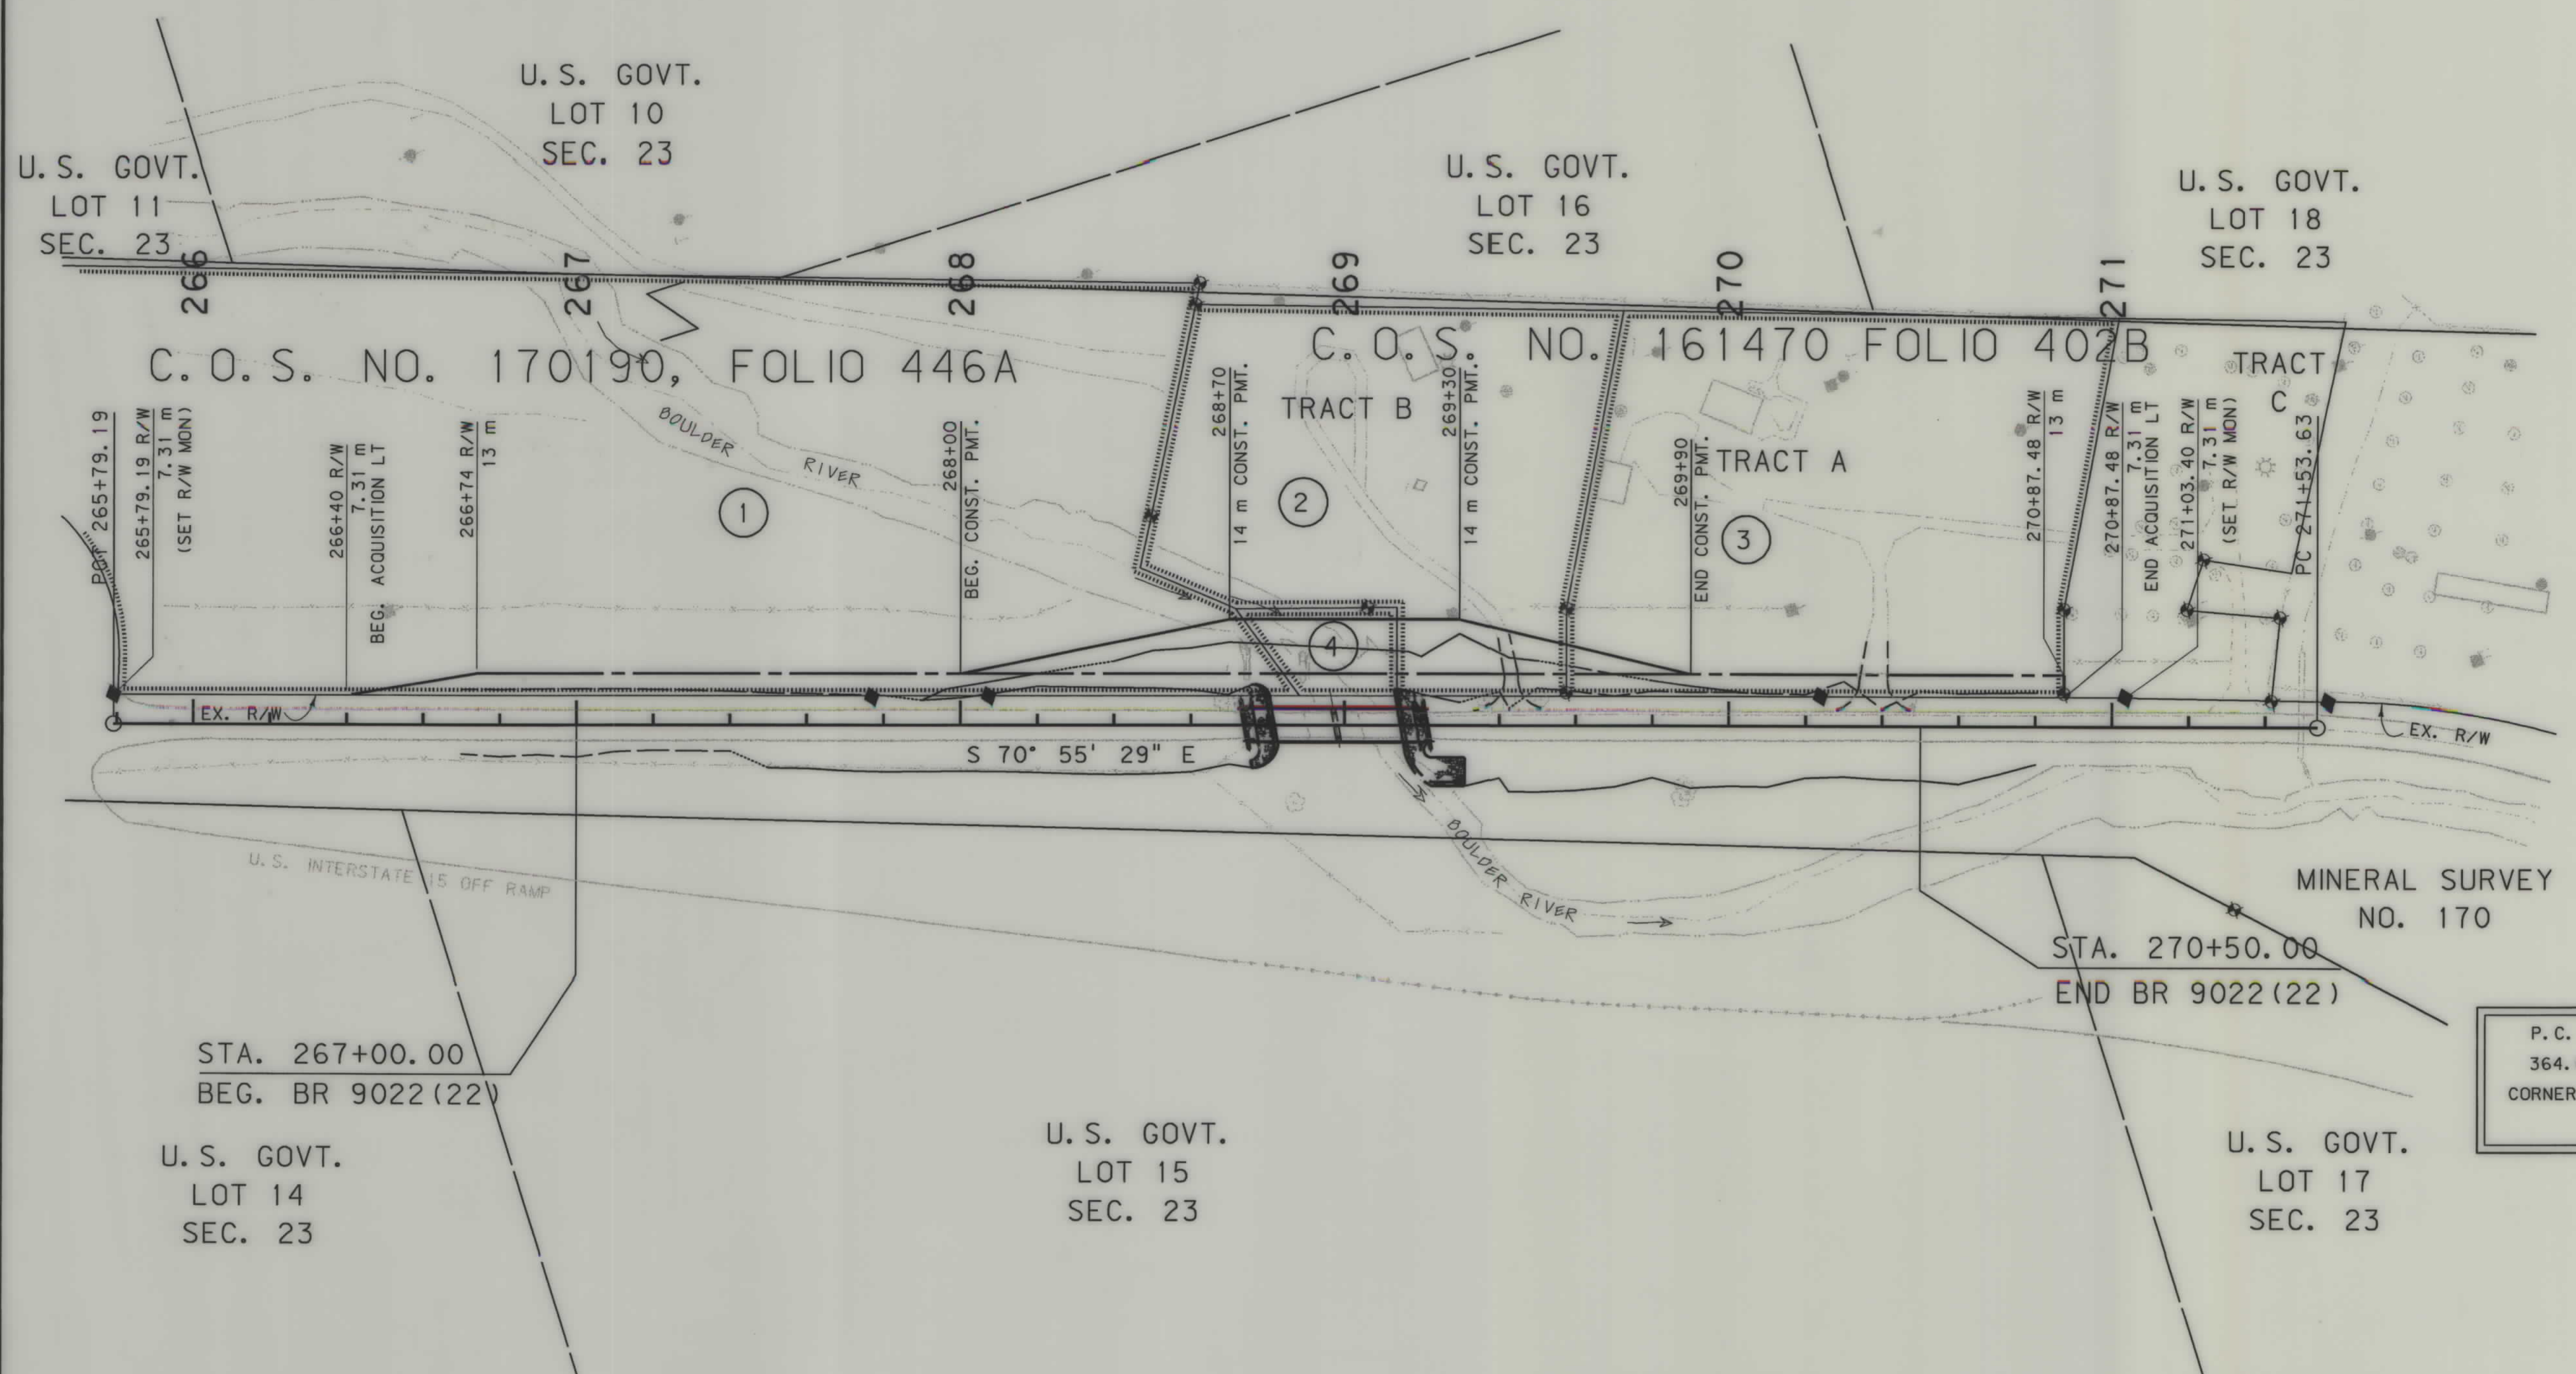

GRID STATE PLANE COORDINATES
THIS IS A STATE PLANE COORDINATE PROJECT. ALL DIMENSIONS, DISTANCES AND AREAS ON THIS PROJECT ARE GRID, EXCEPT FOR THE EXISTING R/W WIDTH, WHICH IS RECORD. THE COMBINATION SCALE FACTOR IS 0.99923935

- NOTES: 1. ALL MEASUREMENTS ARE METRIC EXCEPT AS NOTED
2. THE PROPOSED R/W LINE WHERE A SPIRAL CURVE TRANSITION IS USED IS A CHORD RATHER THAN A CONCENTRIC CURVE.
3. THE ENGLISH AREAS ARE FOR INFORMATIONAL PURPOSES ONLY.
4. ALL STATIONS AND OFFSETS FOR R/W BREAKS ARE IN REFERENCE TO THE R/W BASELINE.

BACKSLOPE LIMITS INCLUDE ROUNDING	
CONSTRUCTION LIMITS:	CUT SECTION TOE OF FILL
FHWA/DOT APPROVAL	6/28/01
MAP REVISED	

MONTANA
DEPARTMENT OF TRANSPORTATION

RIGHT OF WAY PLAN
JEFFERSON COUNTY

SCALE 1:1000

BR 9022(25) SH