


PLANS

NOT

TO

SCALE

RED LODGE-COOKE CITY HIGHWAY

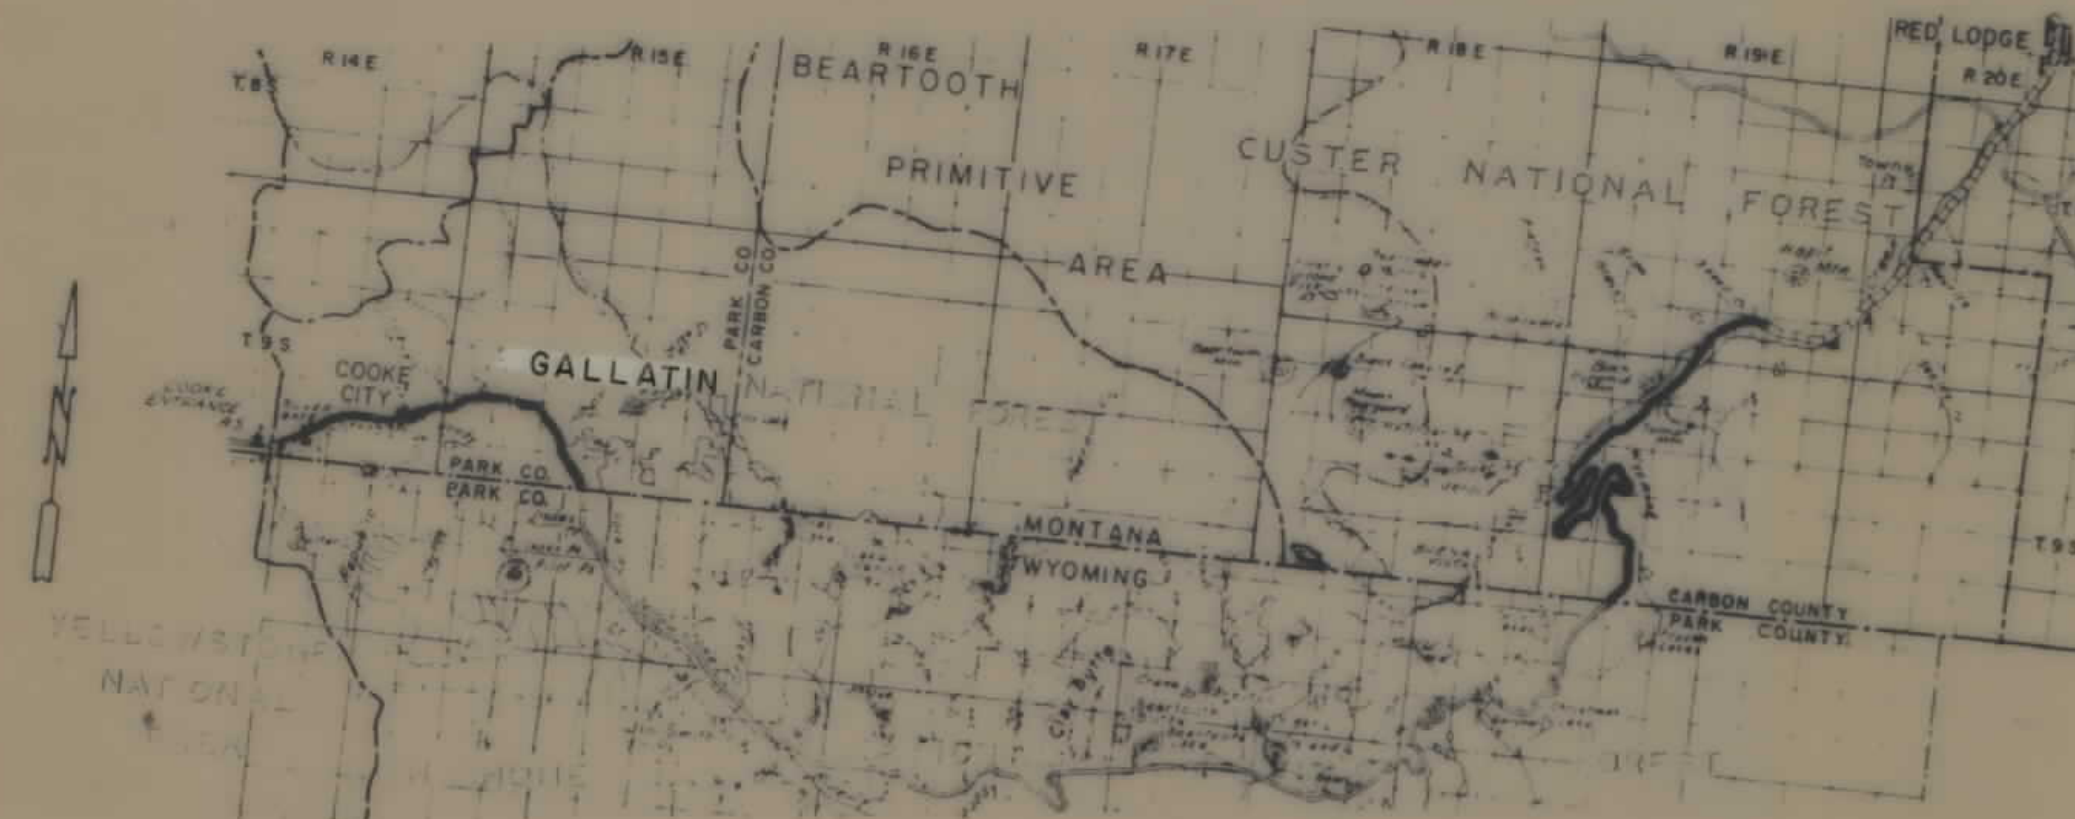CUSTER NATIONAL FOREST
CARBON COUNTY


SCALE OF MILES

FOREST HIGHWAY ROUTE 59


PROJECTS 59-2(1), F.L. 59(1),
F.L. 59-2, F.H. 59-2(2),
PHP 59DRIGHT OF WAY PLANS AFFECTING
NATIONAL FOREST SYSTEM LANDS
IN THE CUSTER AND GALLATIN
NATIONAL FORESTS IN CARBON AND
PARK COUNTIES, MONTANA


APPROVED FOR RIGHT OF WAY PURPOSES:

 FEDERAL HIGHWAY ADMINISTRATION


 Merlin J. Voegelé, Division
 Right of Way Officer

 
MONTANA DEPARTMENT OF HIGHWAYS

 
 Jack R. Ricker, Chief- Right
 of Way Bureau


 FOREST ENGINEER
 12/16/85



BASIS OF BEARINGS UNKNOWN

NFSL EASEMENT AREA


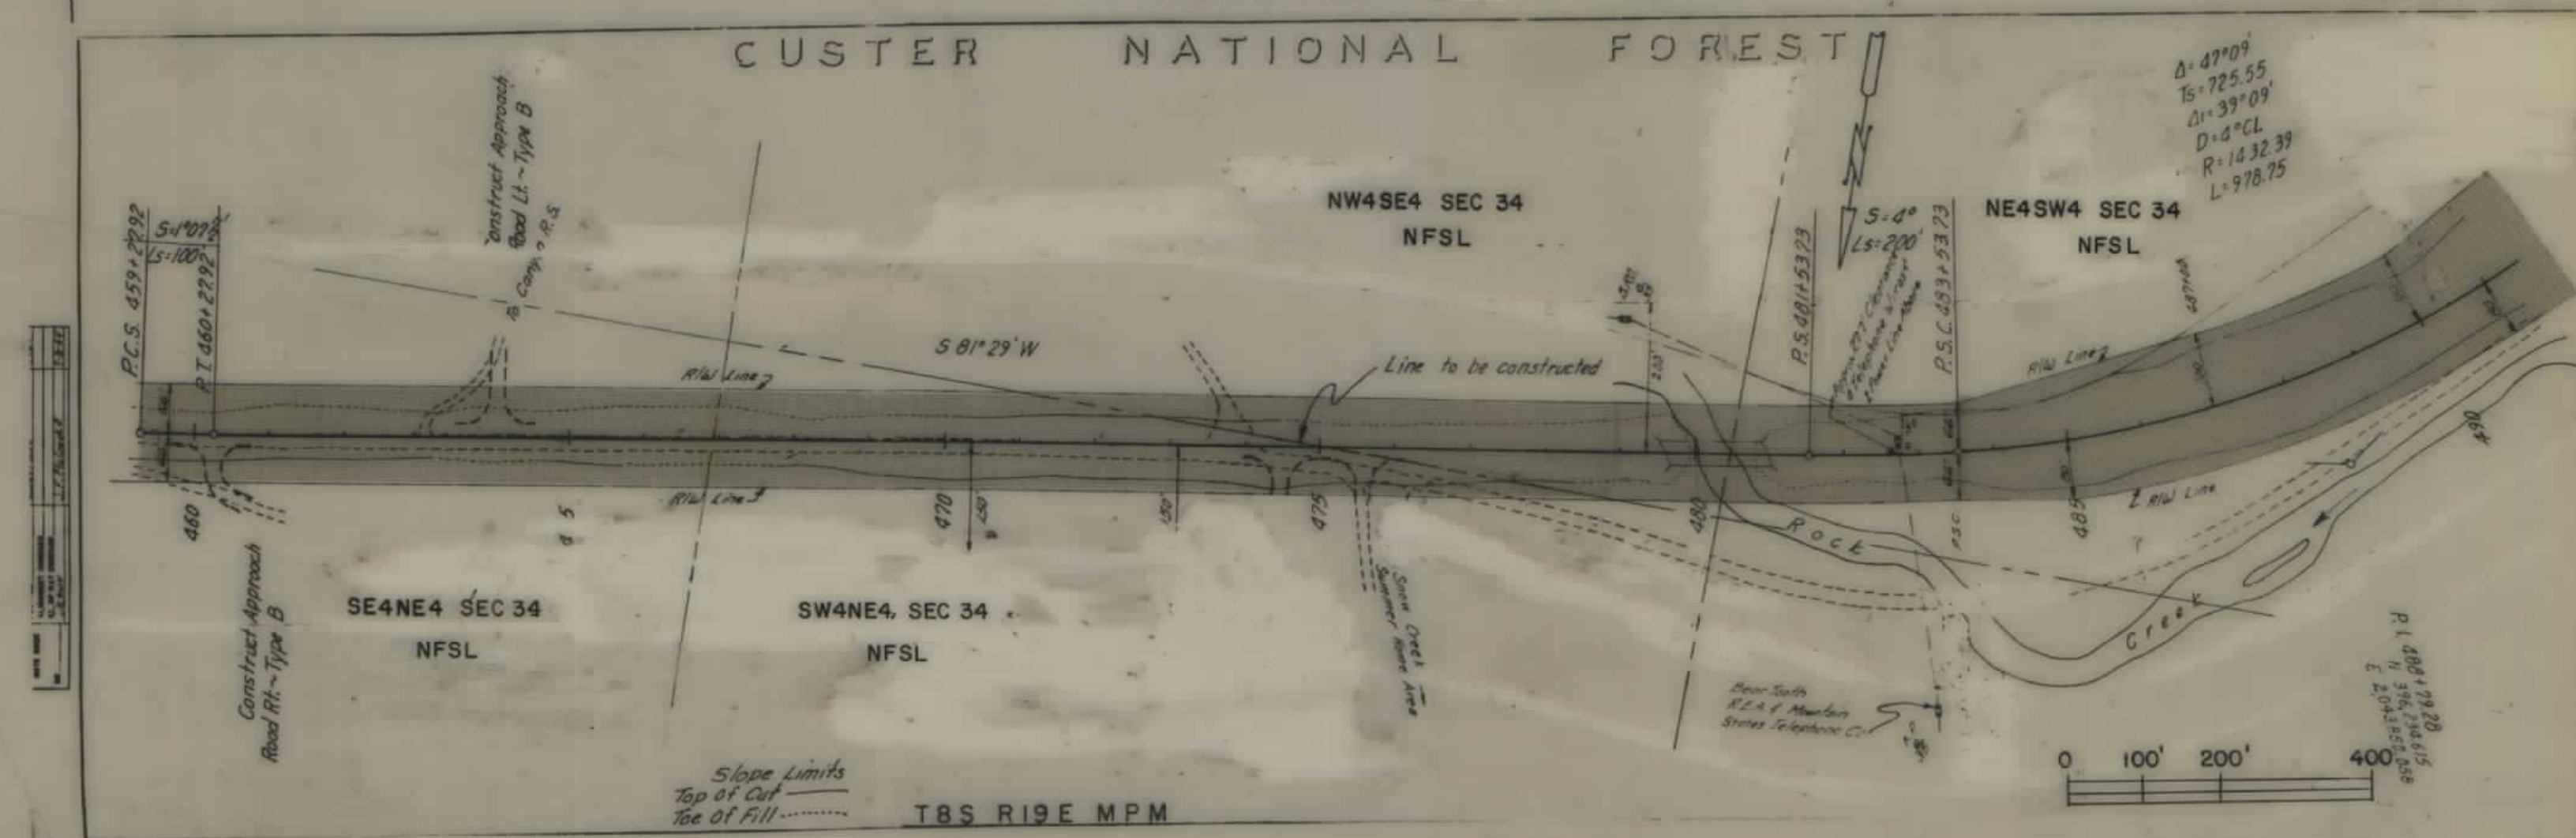


CLUSTER NATIONAL FOREST

TWP 9S RGE 19E PMM

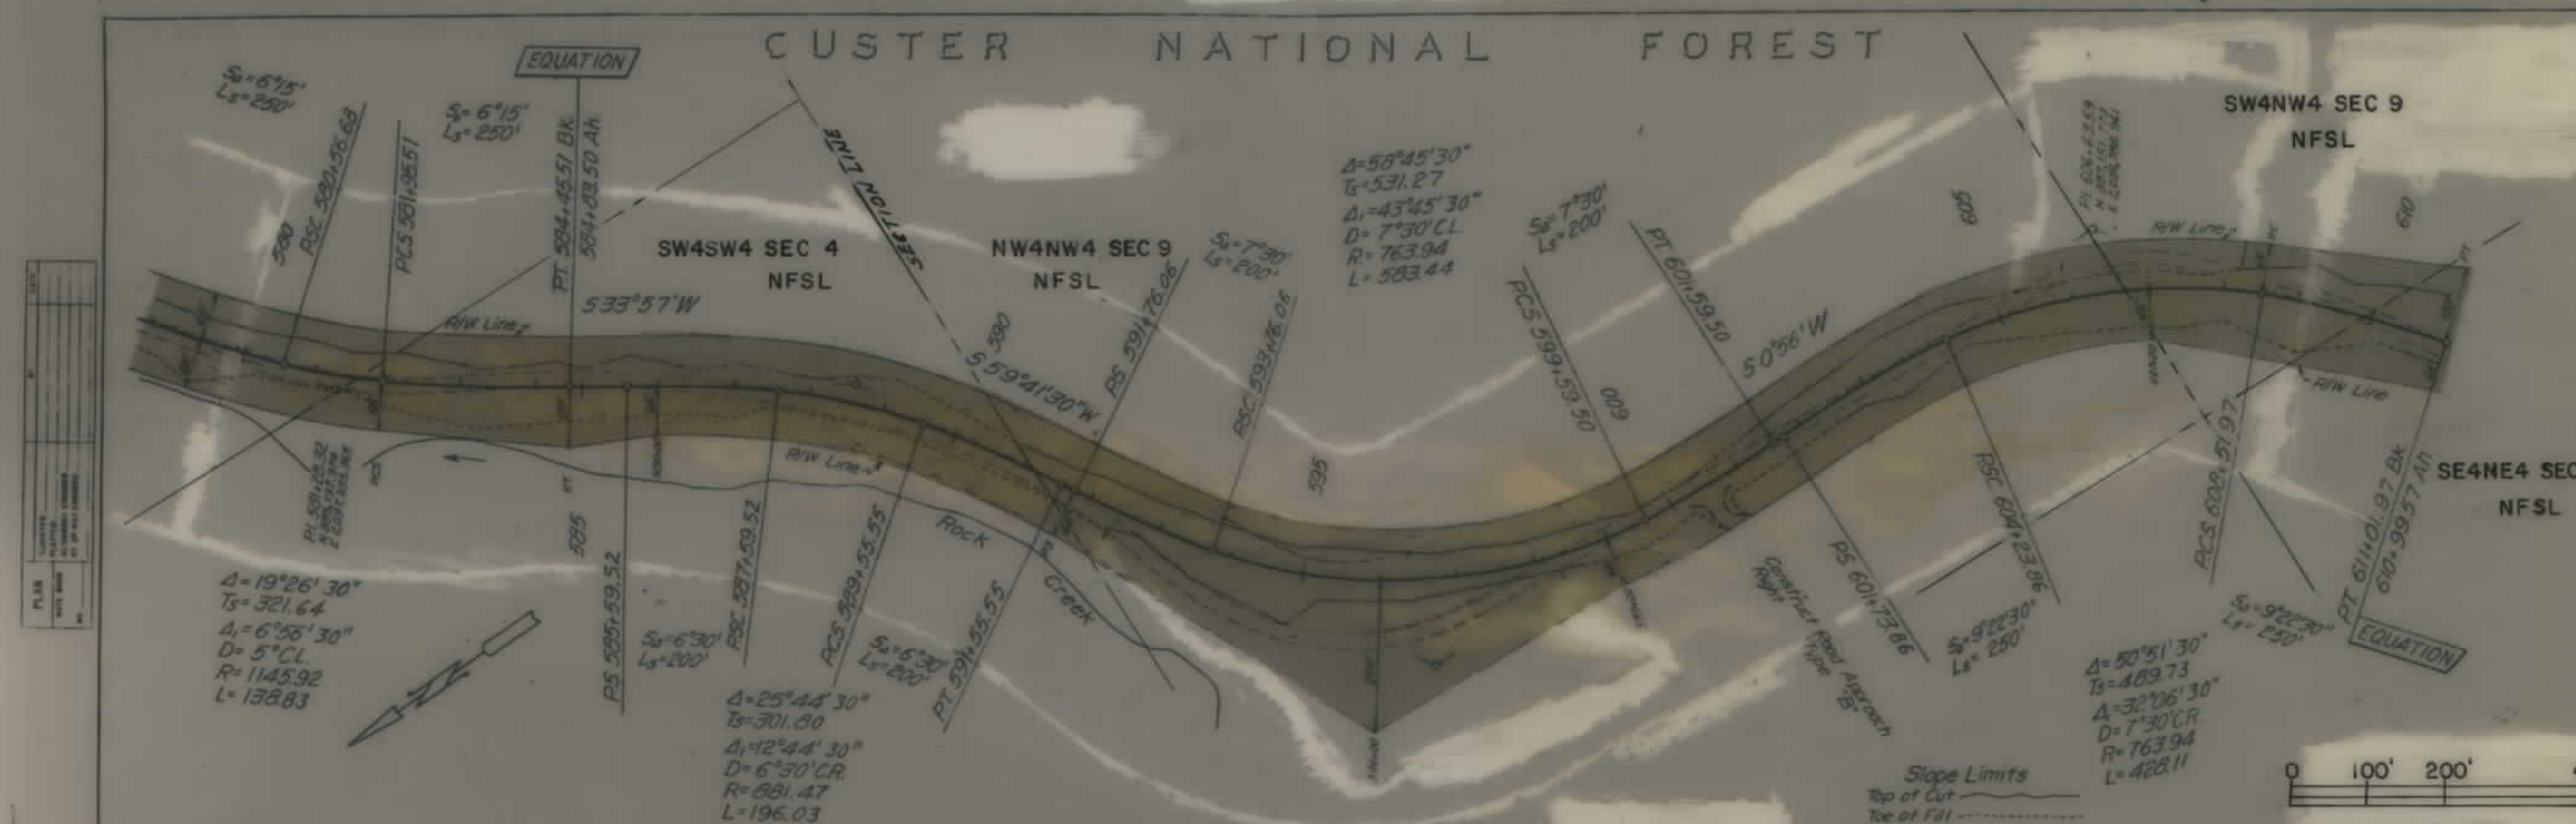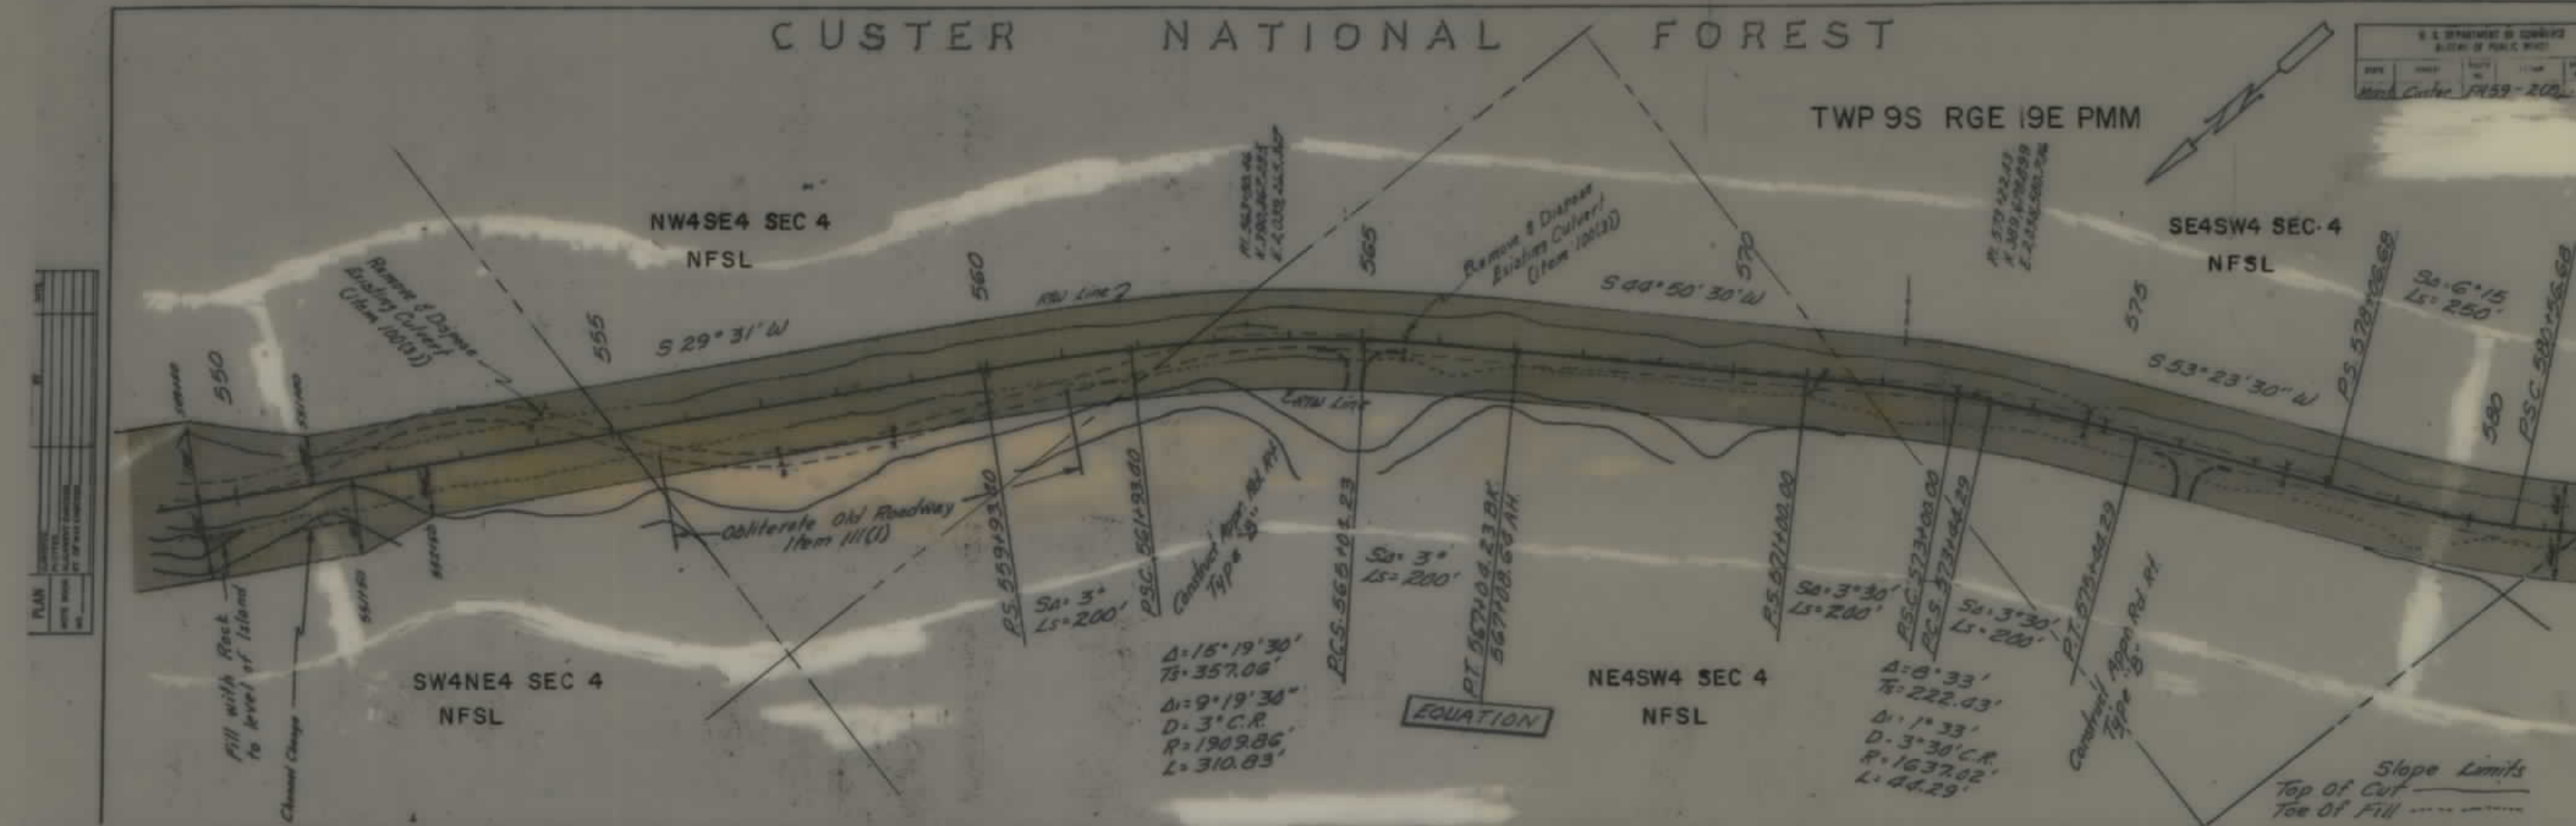

U.S. DEPT. OF COMMERCE BUREAU OF PUBLIC ROADS				
DATE	PROJECT	SECTION	SHEET	TOTAL SHEETS
1954	Cluster	FM 59-2(2)	6	21

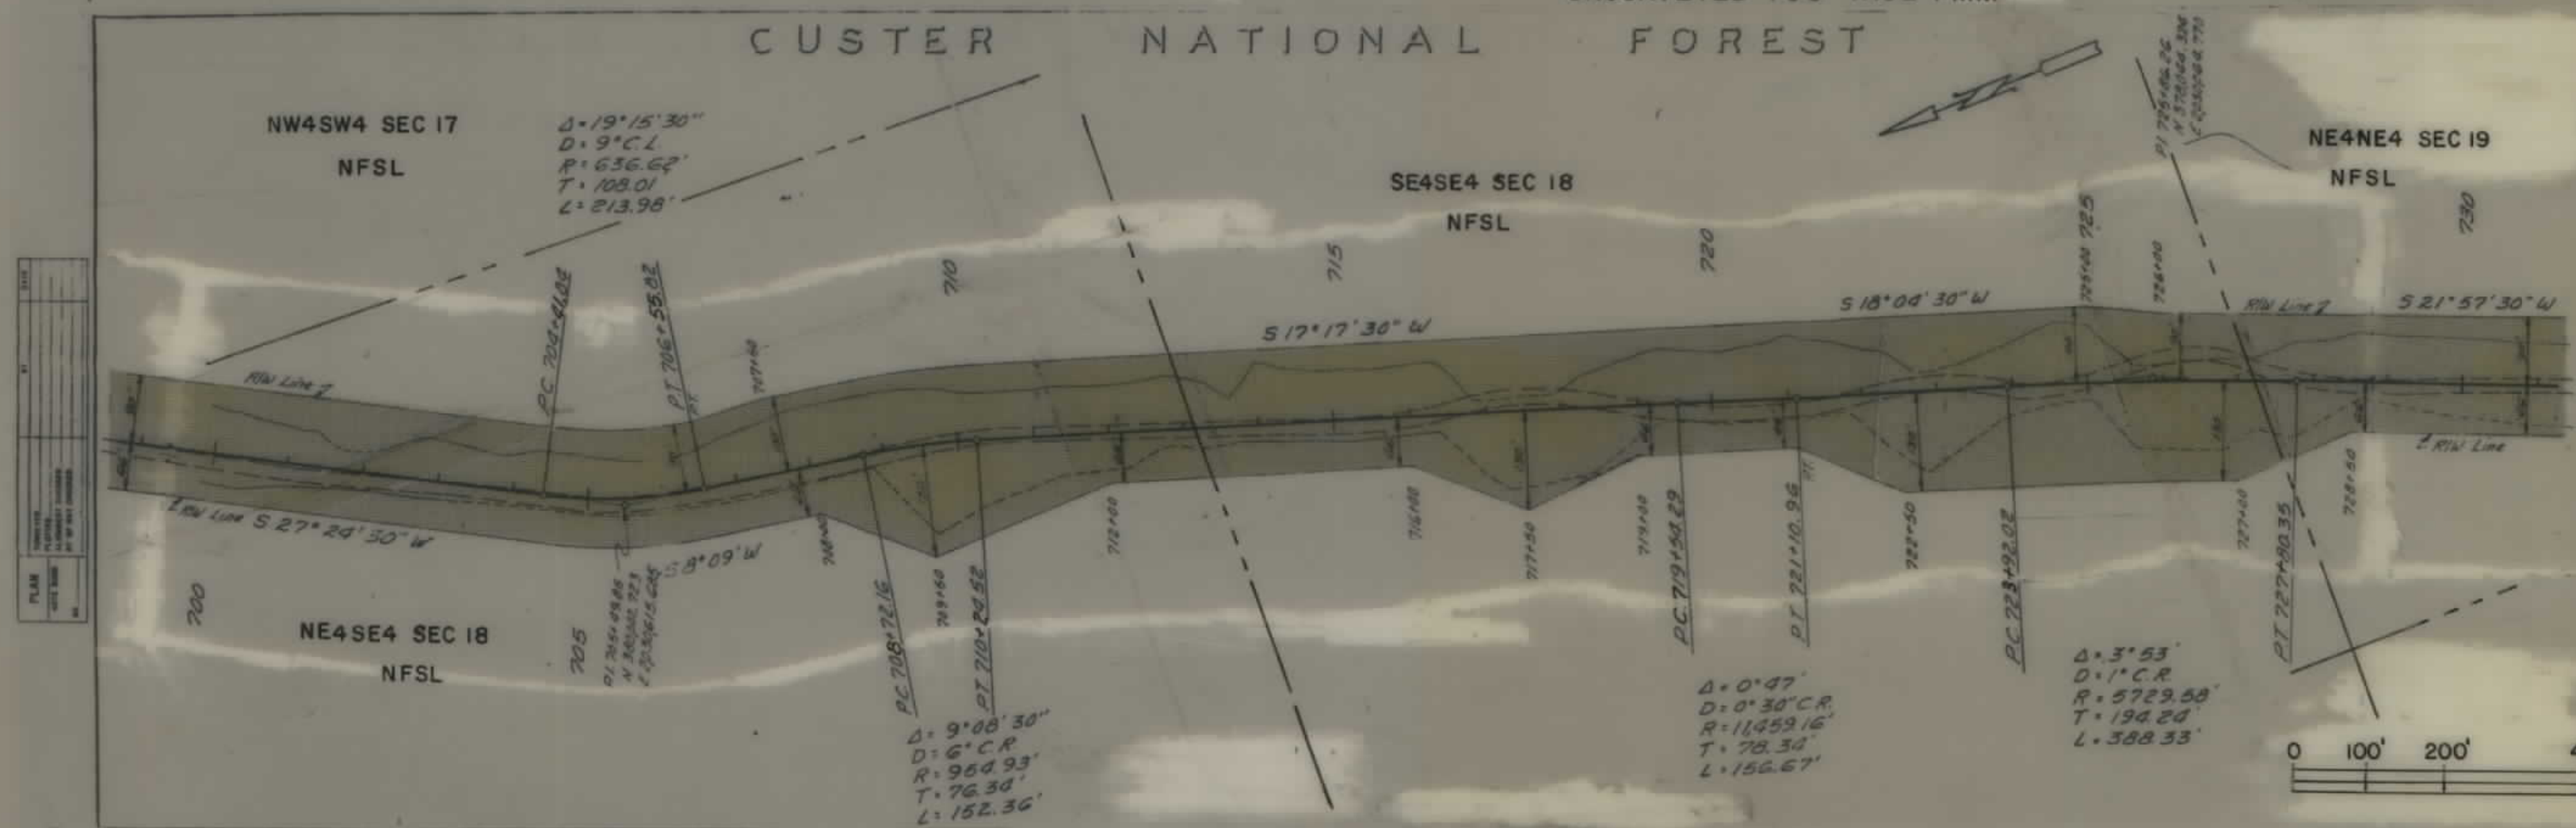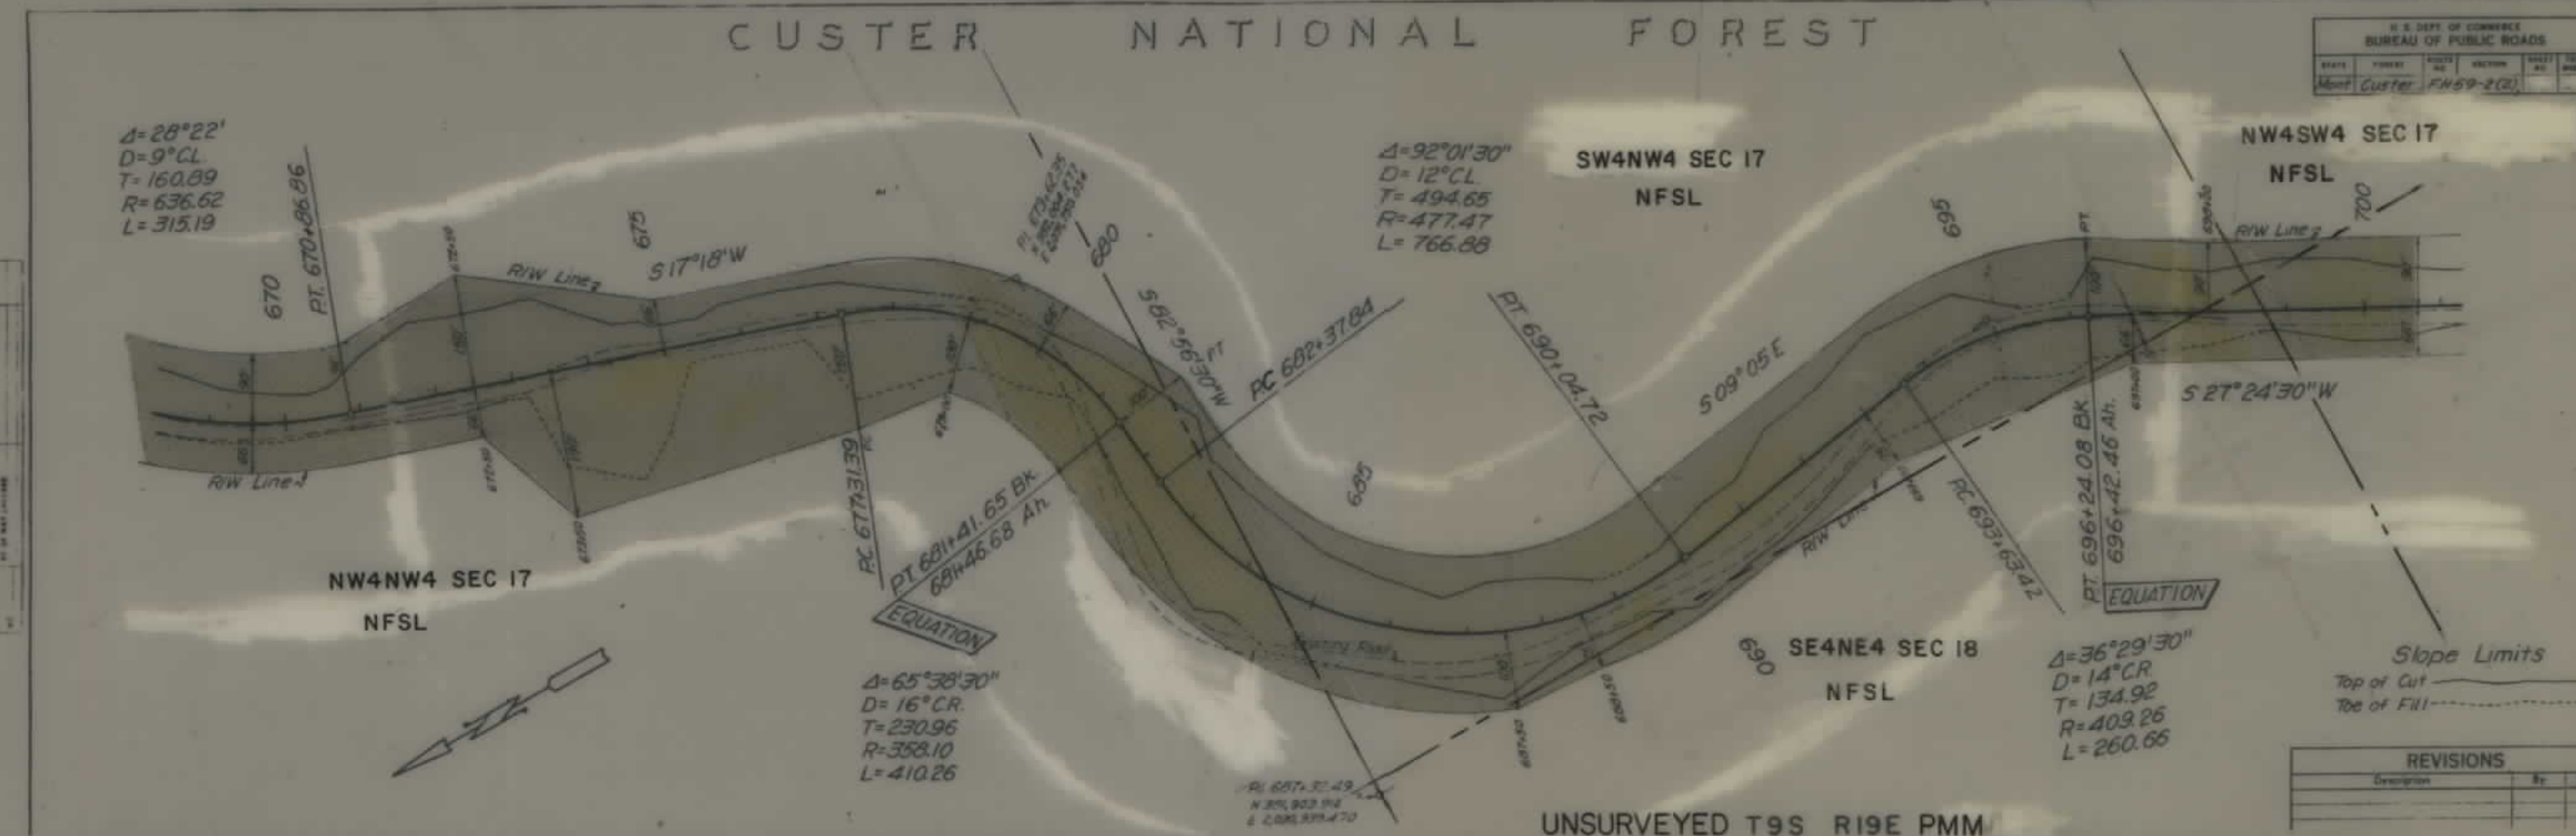

CUSTER NATIONAL FOREST

SHEET 8 OF 21

U.S. DEPT. OF COMMERCE

BUREAU OF PUBLIC ROADS

STATE PROJECT NO. SECTION

MENT CUST 59 211

UNSURVEYED TWP 9S RGE 19E PMM.

NE4NE4 SEC 19
NFSL

SE4SE4 SEC 18
NFSL

SW4SW4 SEC 17
NFSL

STA. 786+72 BEGIN PROJECT
NO. 59-2(1), FL. 59(1), FL. 59(2)

Slope Limits
Top of Cut
Toe of Fill

REVISIONS

CUSTER NATIONAL FOREST

SW4NW4 SEC 17
NFSL

NW4SW4 SEC 17
NFSL

SE4NW4 SEC 17
NFSL

NE4SW4 SEC 17
NFSL


SW4SW4 SEC 17
NFSL


Constructed Type 2 Marker
Blanket (See sheet No. 35 for details)

Slope Limits
Top of Cut
Toe of Fill



0 100' 200'

 
FHP 59-2(1) ... SHT 8 OF 21



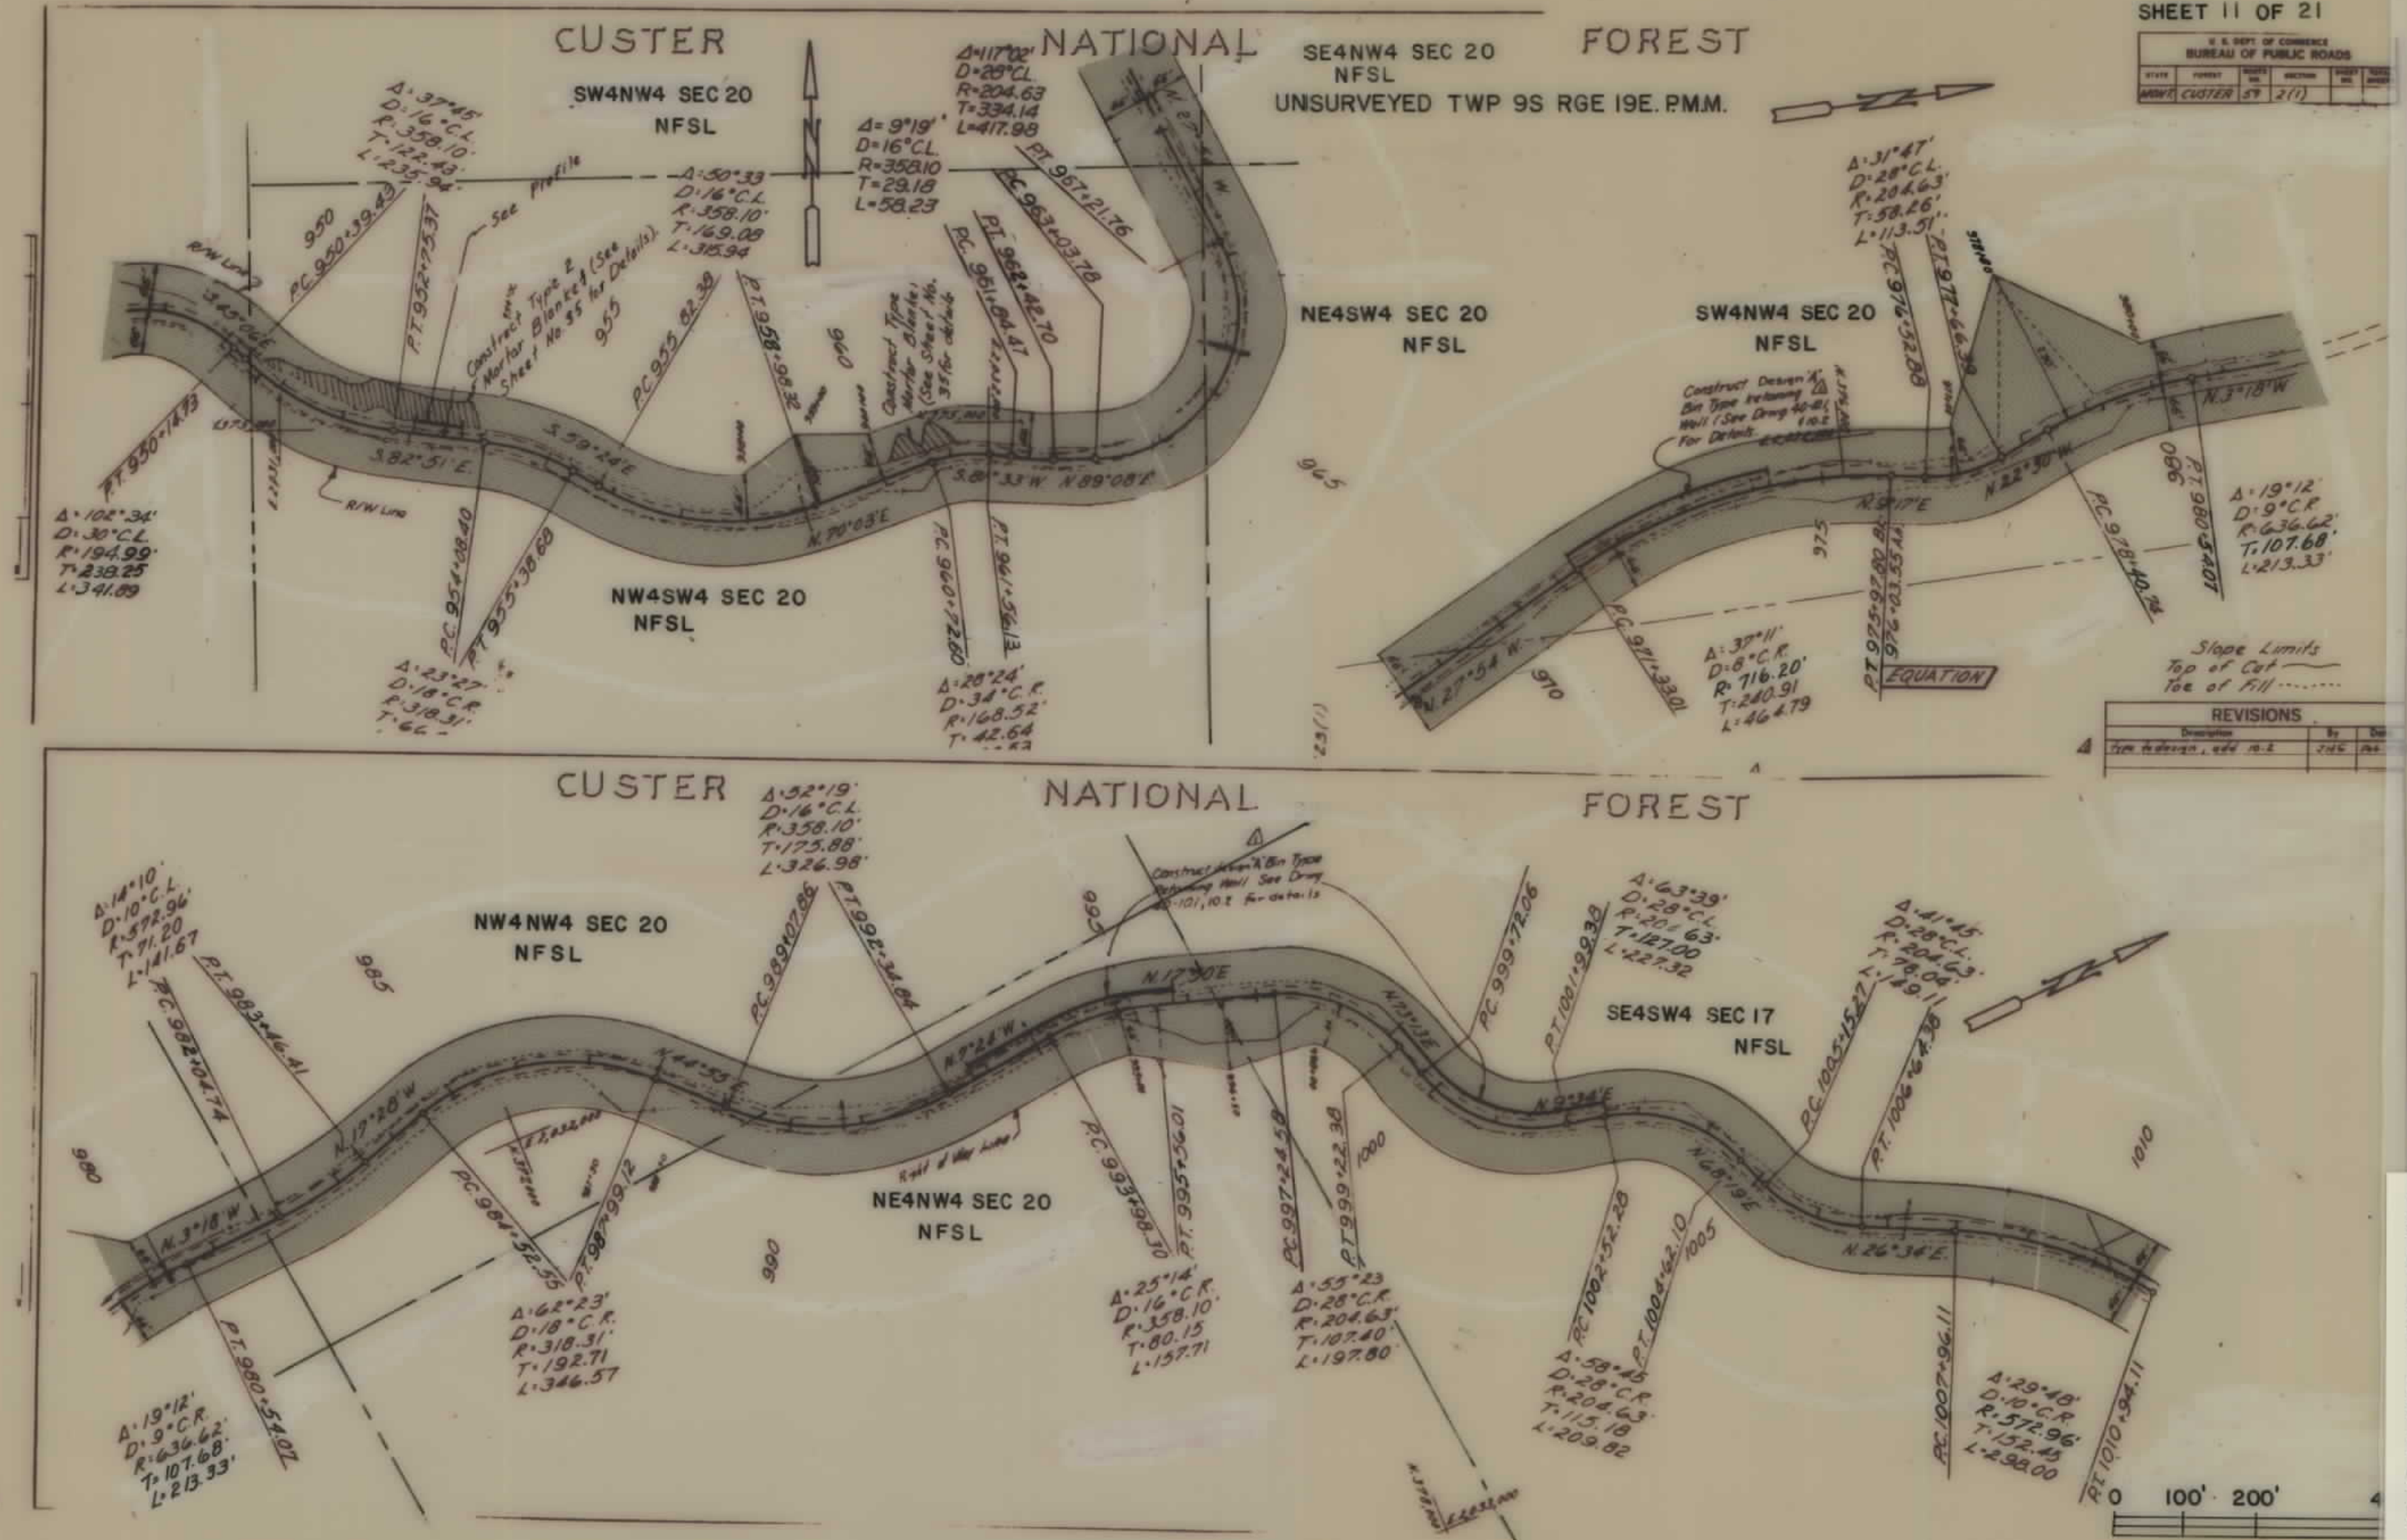

FHP 59-2(1)... SHT 11 OF 21

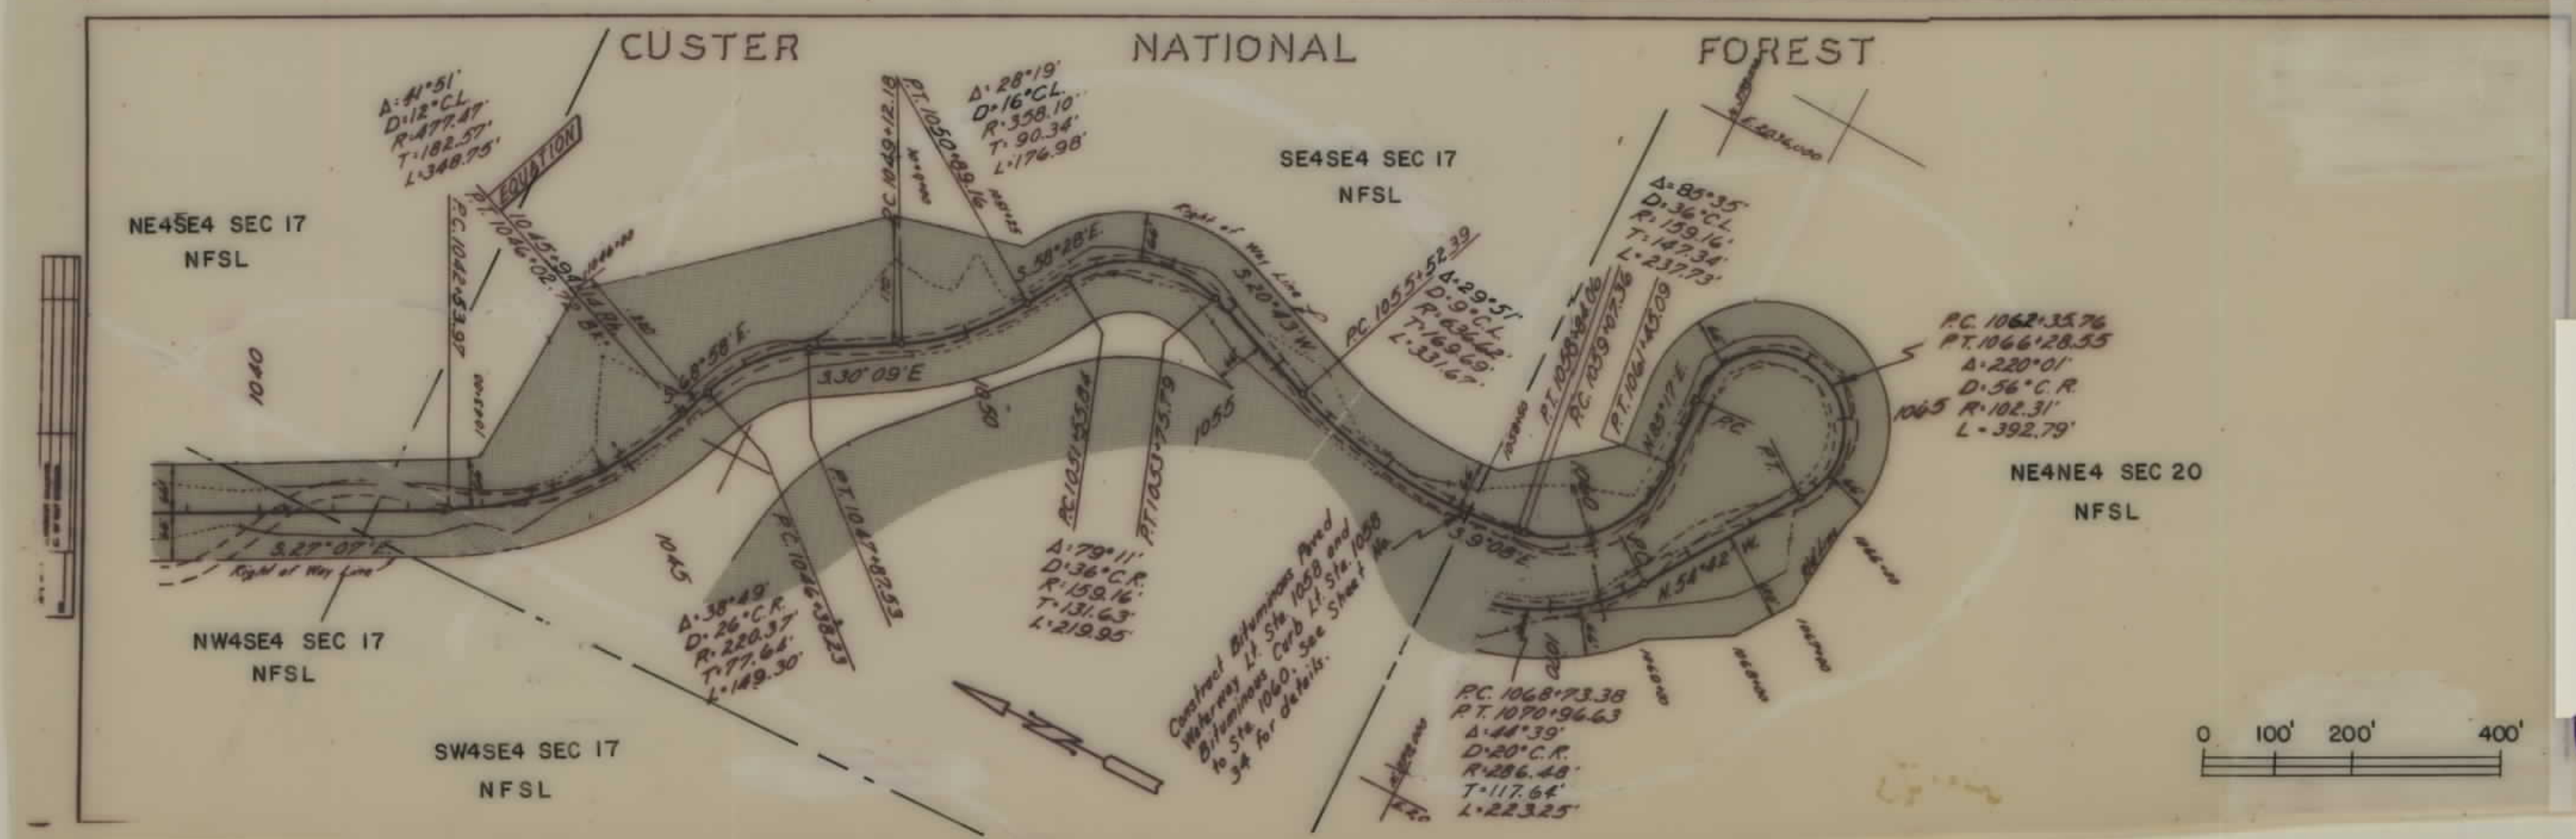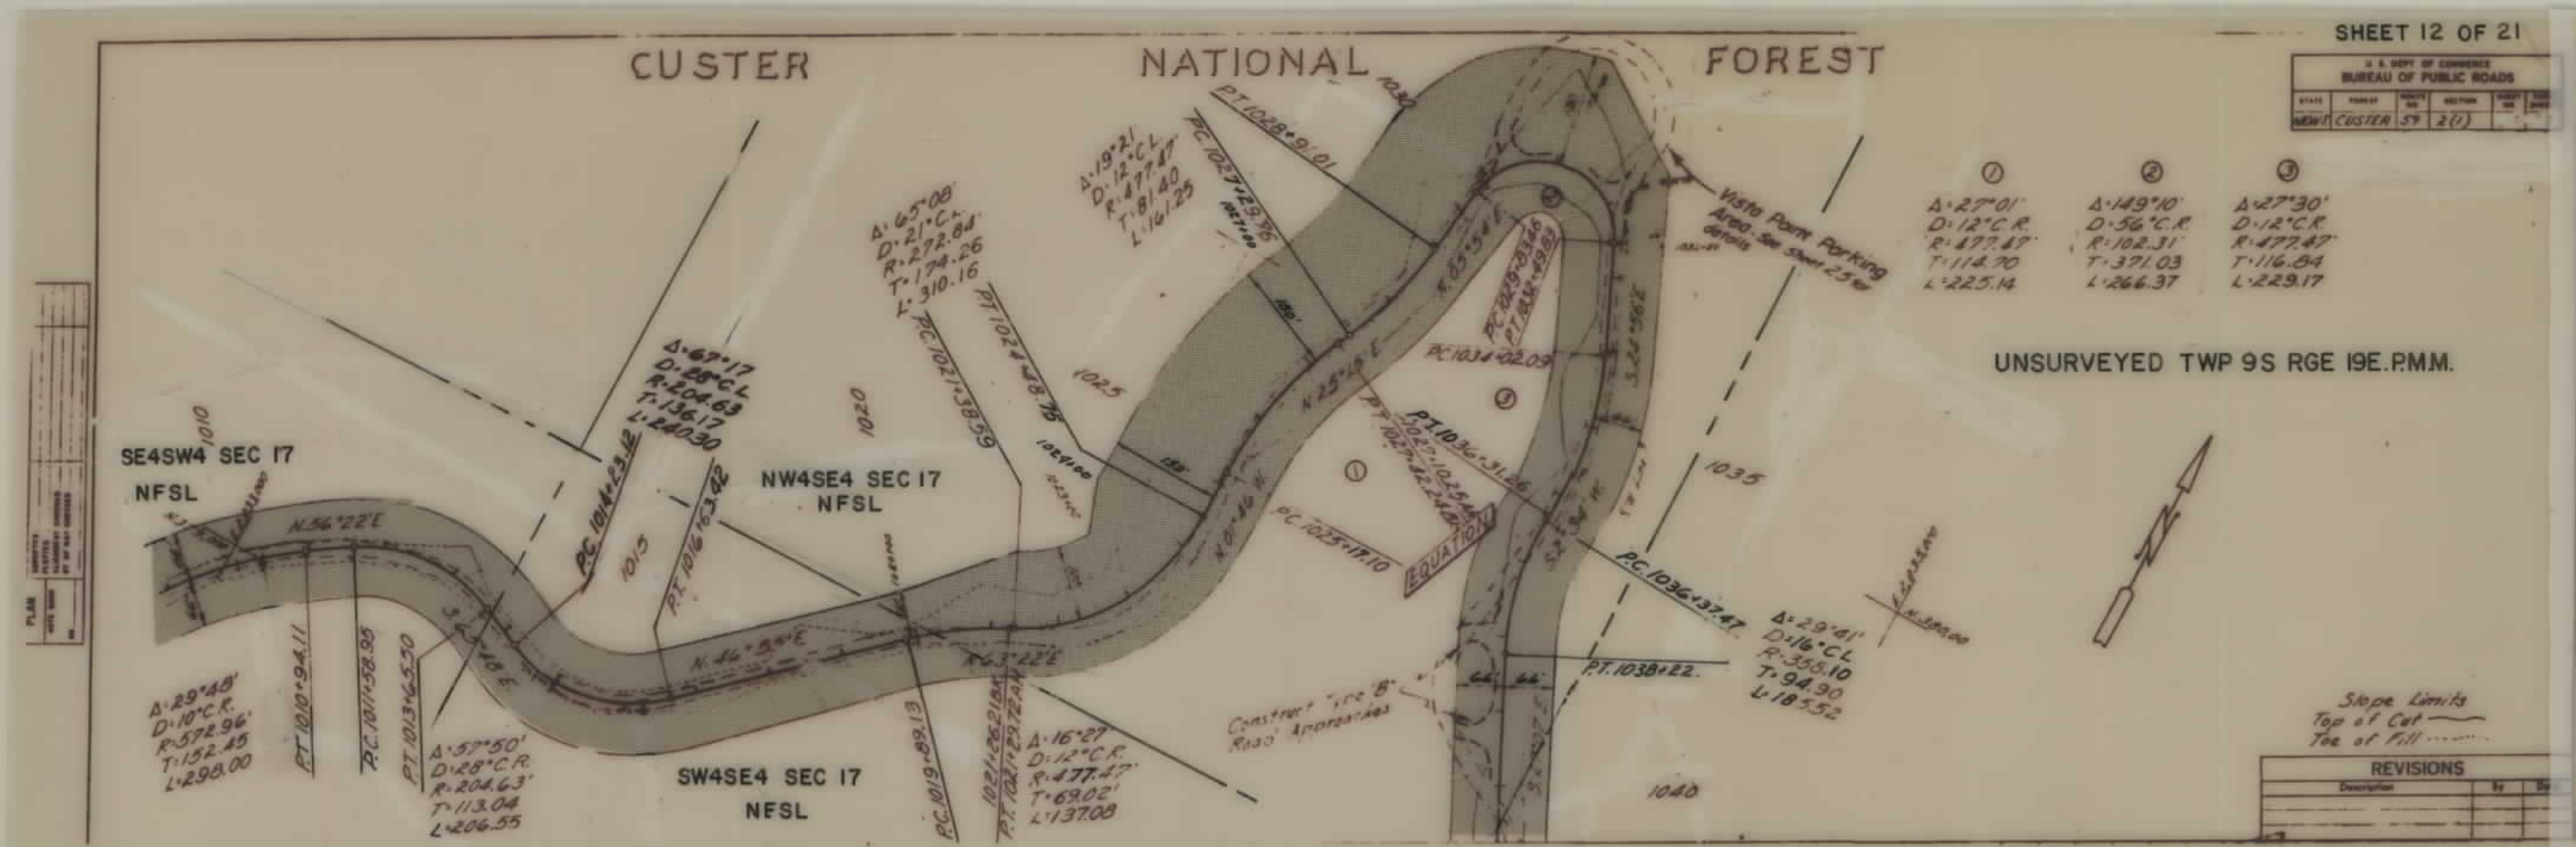


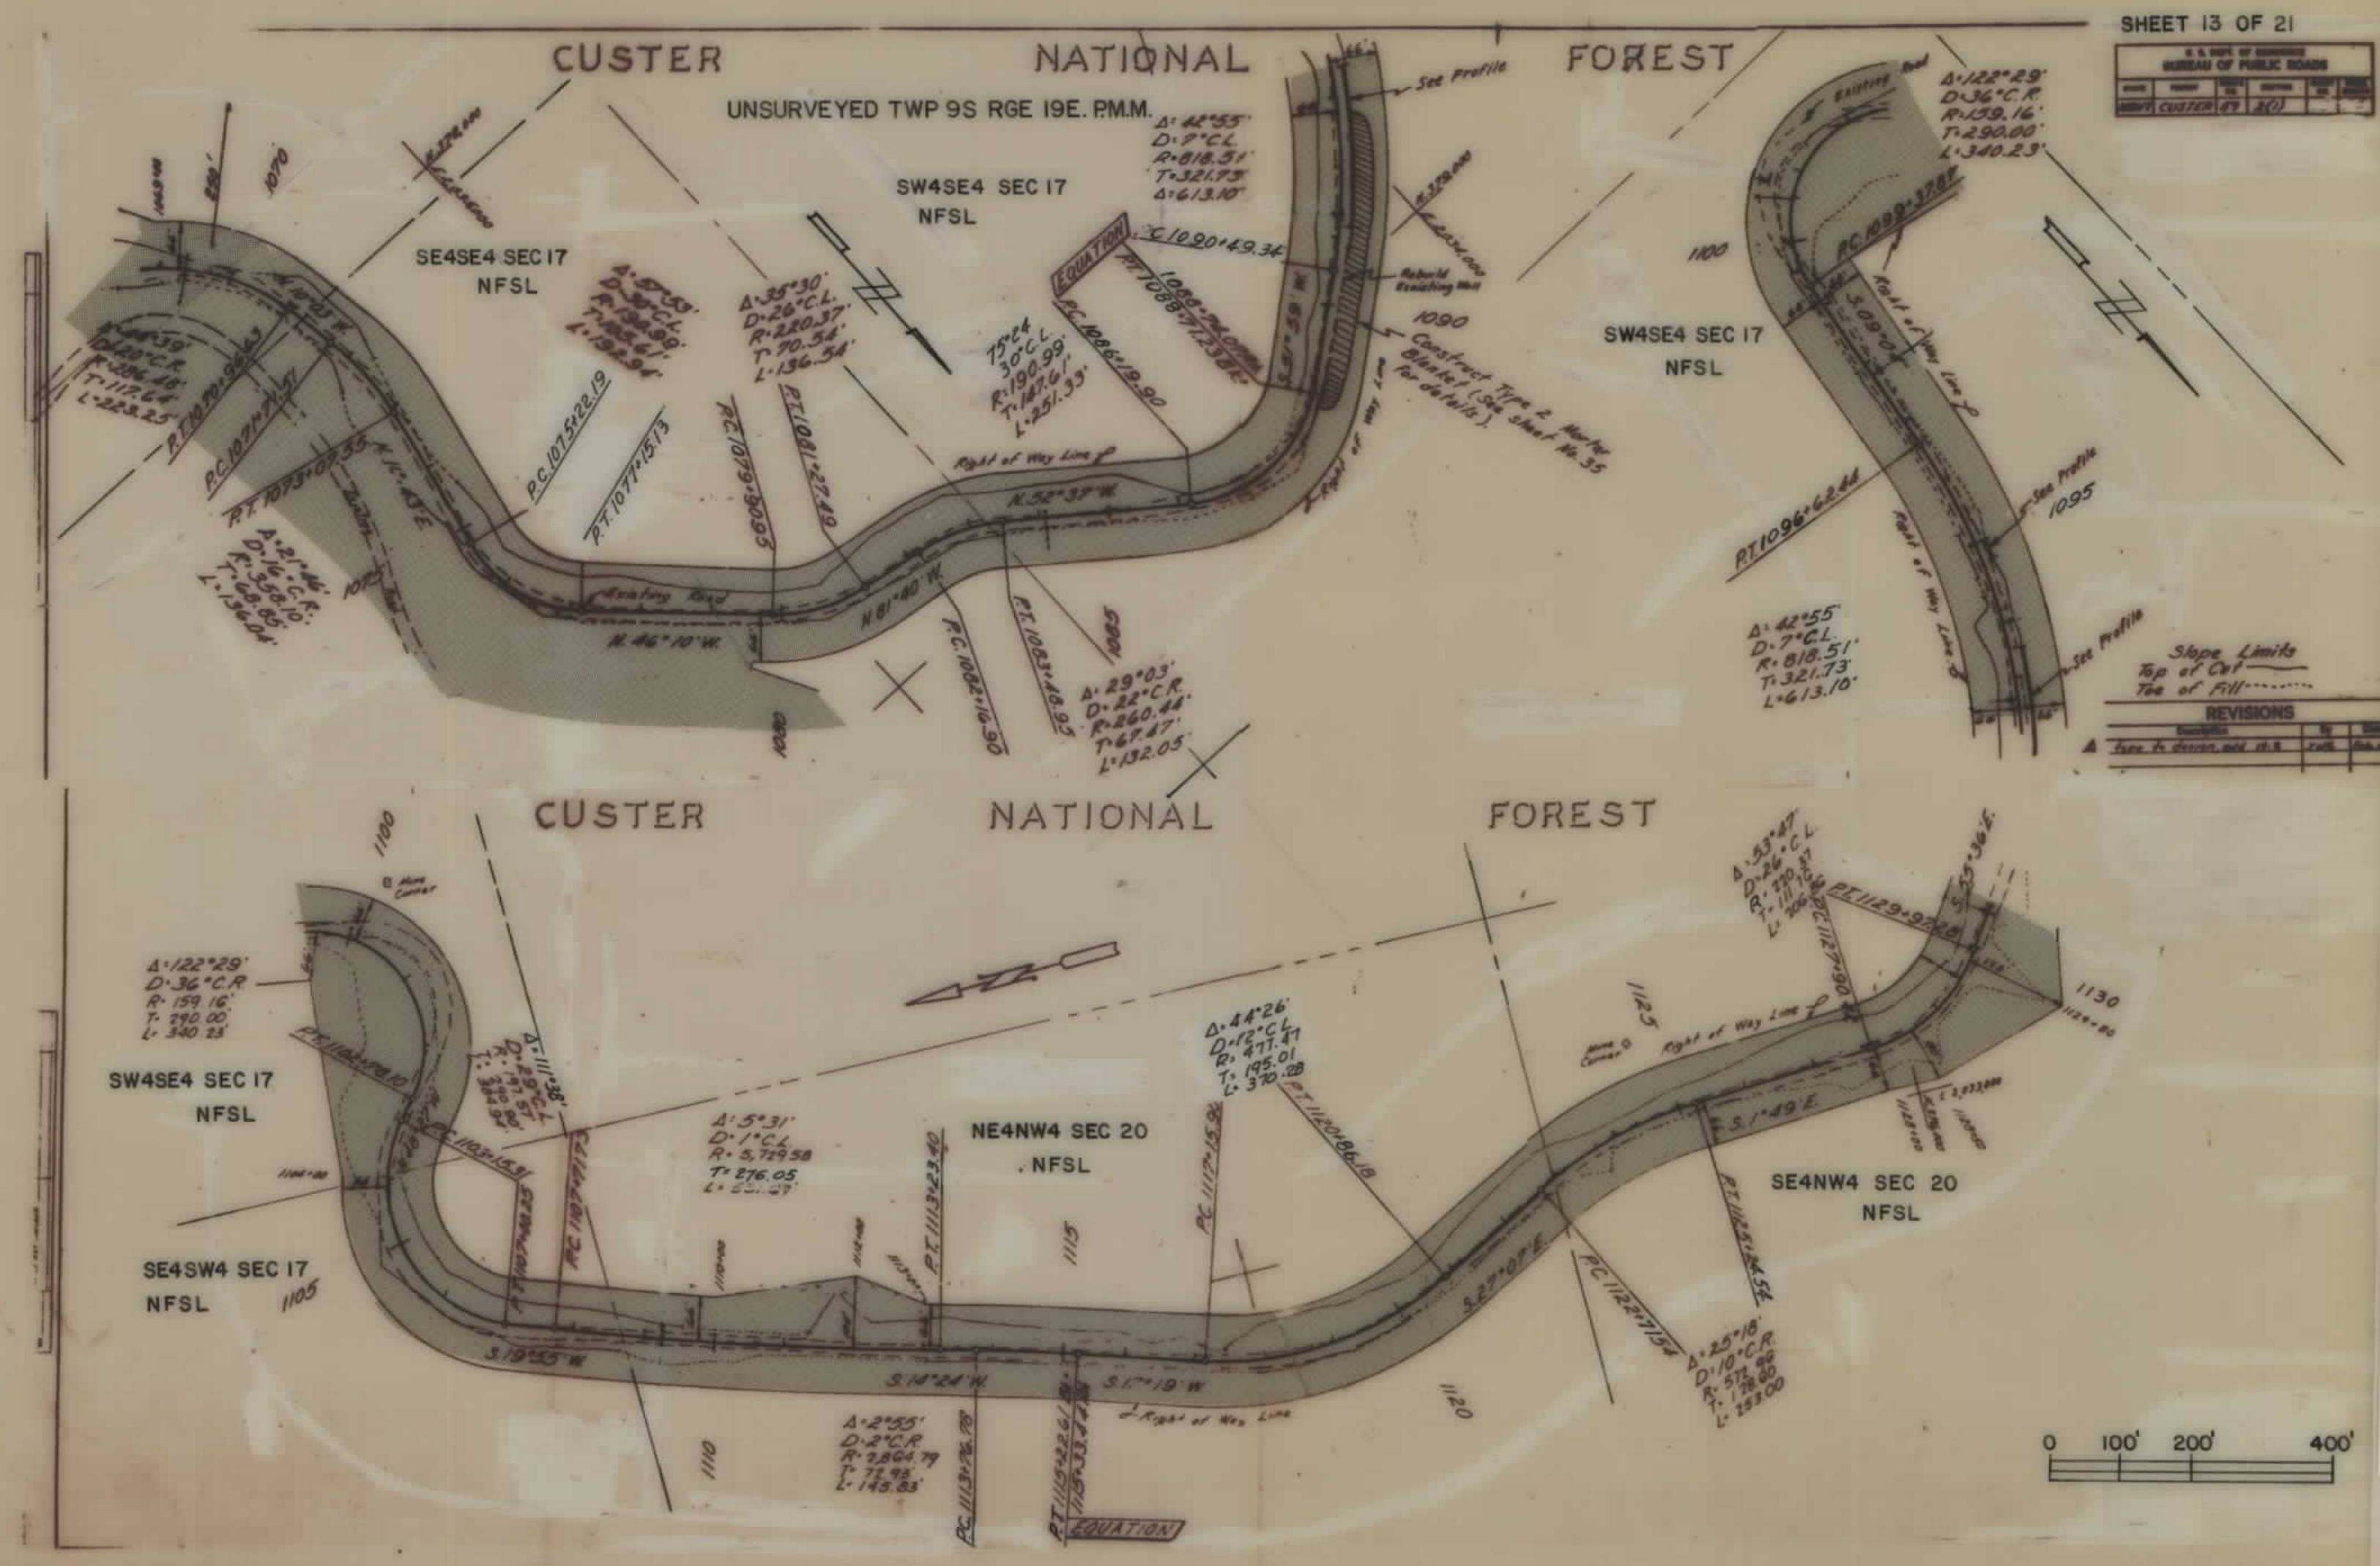

SHEET 13 OF 21

REVISIONS	
No.	Description
1	As shown, add, or delete



FHP 59-2(1)... SHT 13 OF 21

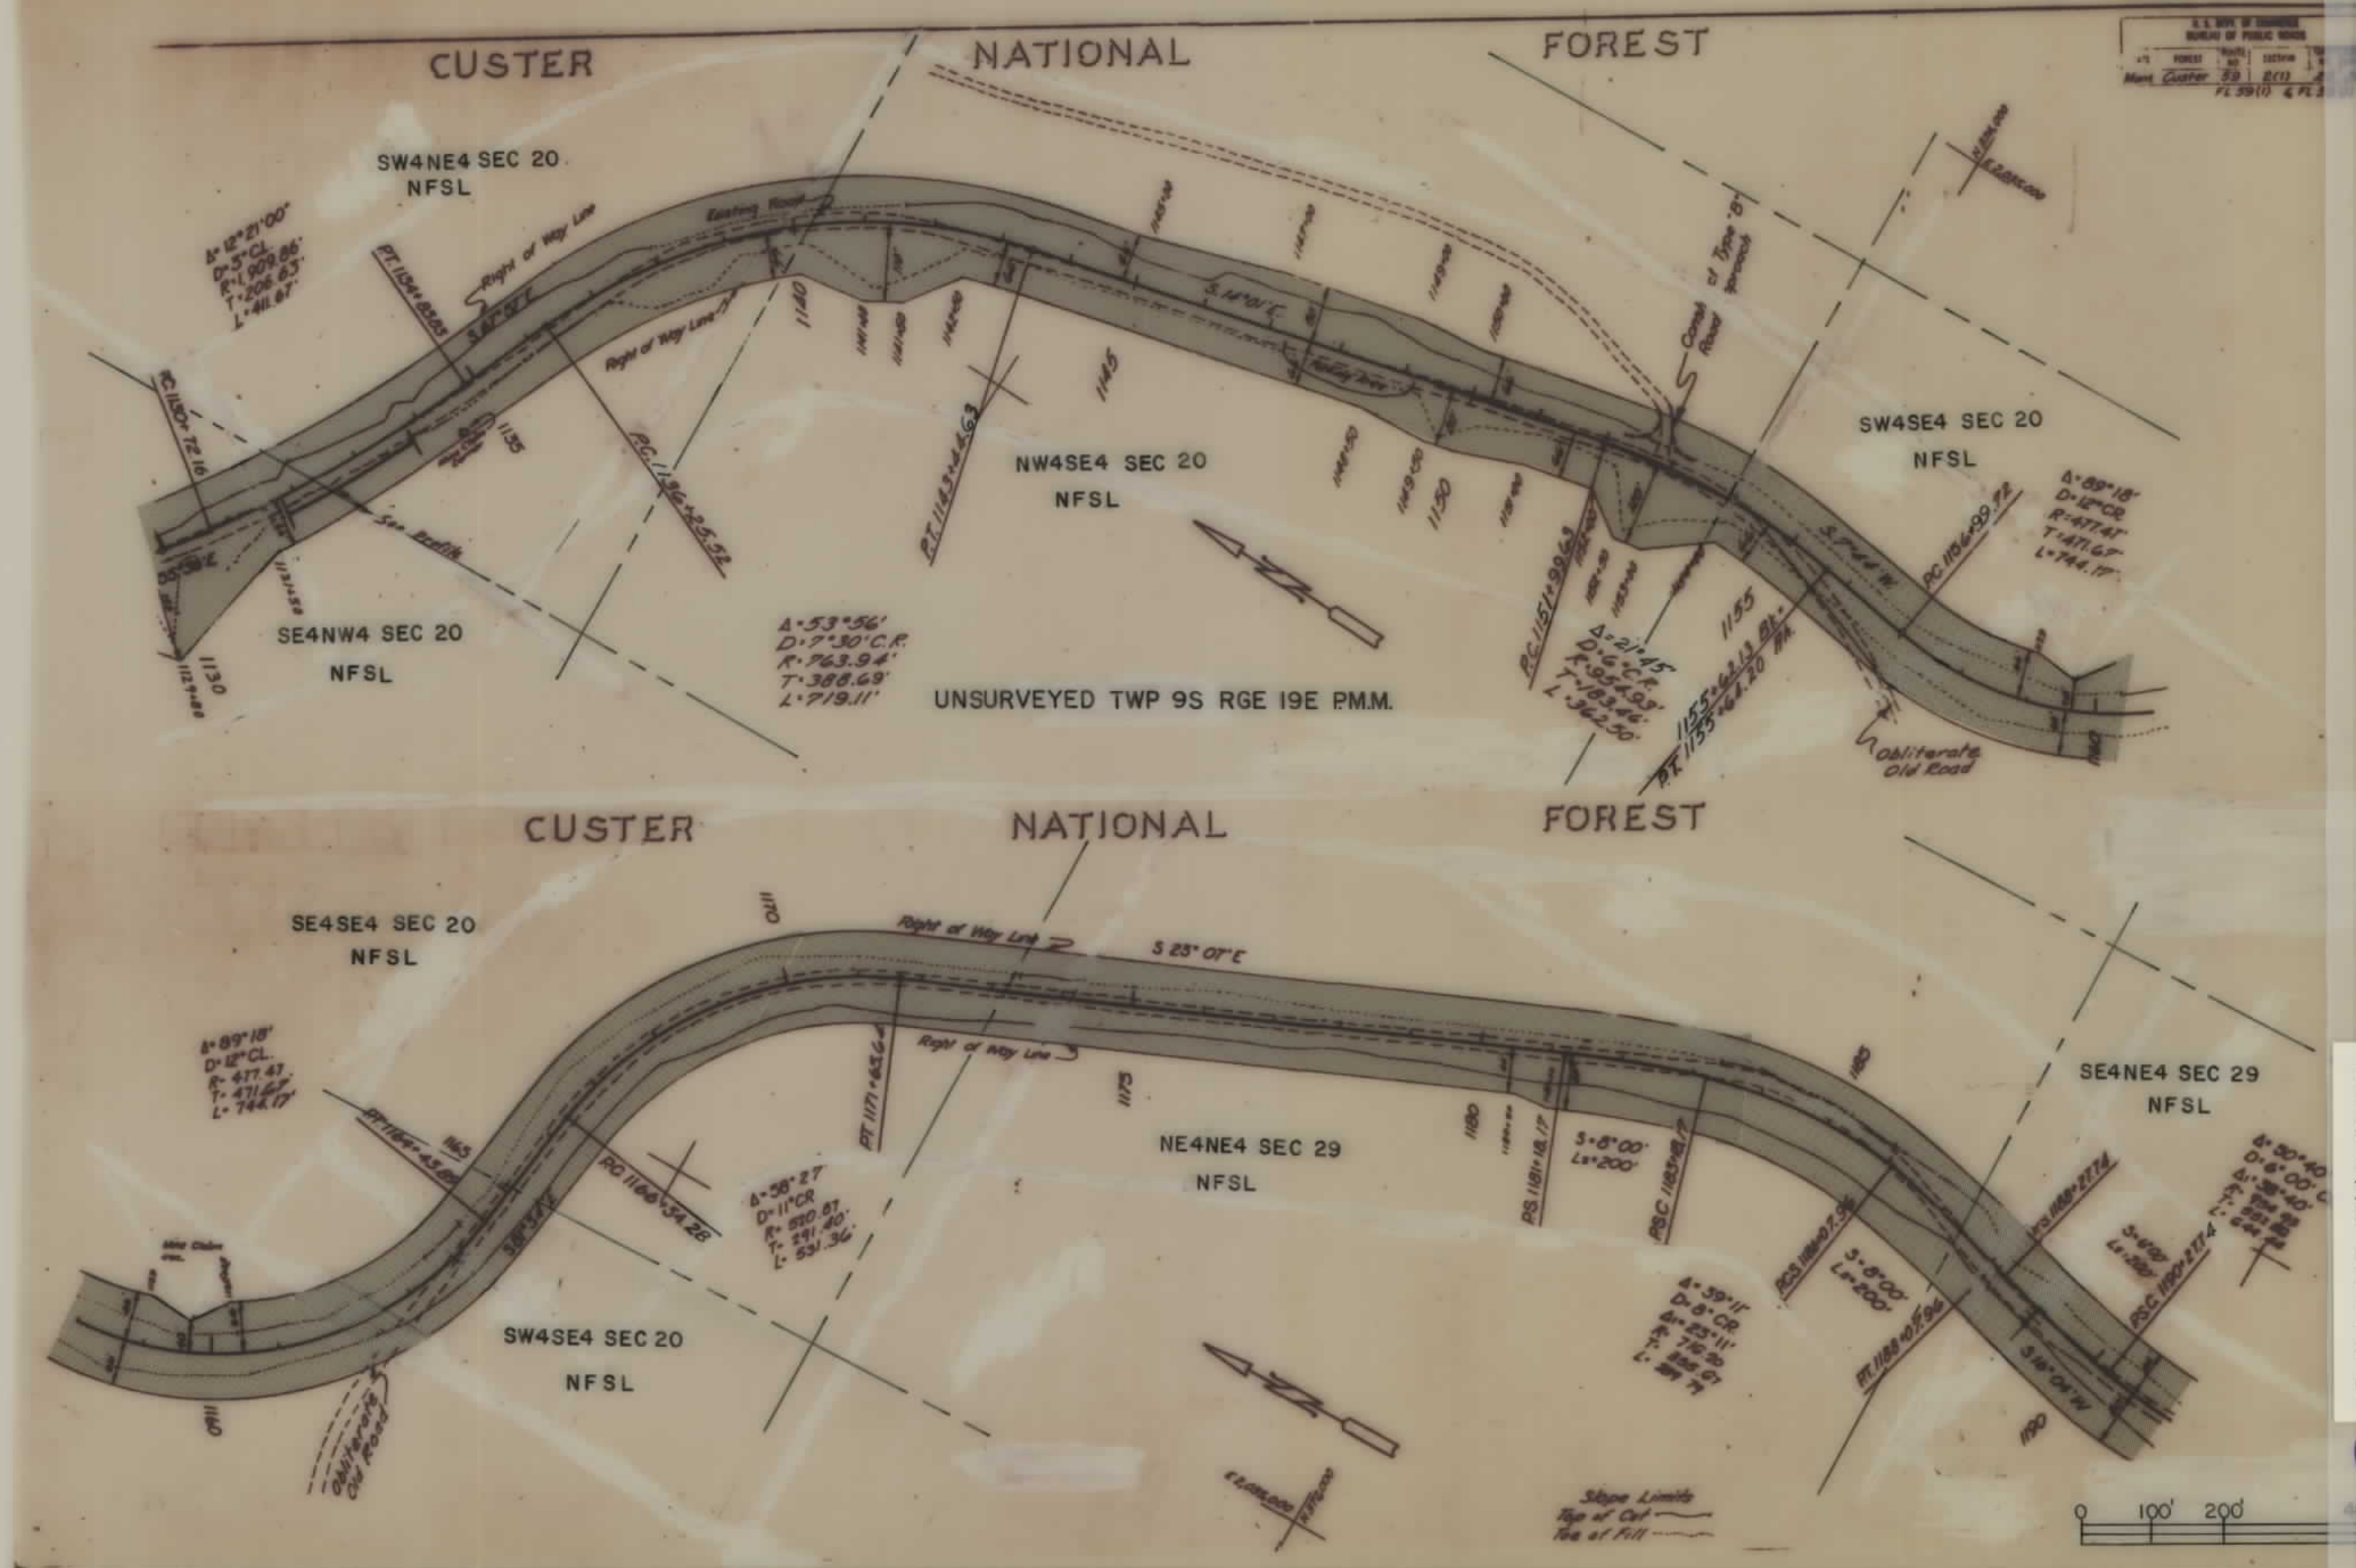

FHP 59-2(1)... SHT 14 OF 21

5

UNSURVEYED TWP 9S RGE 19E PMM

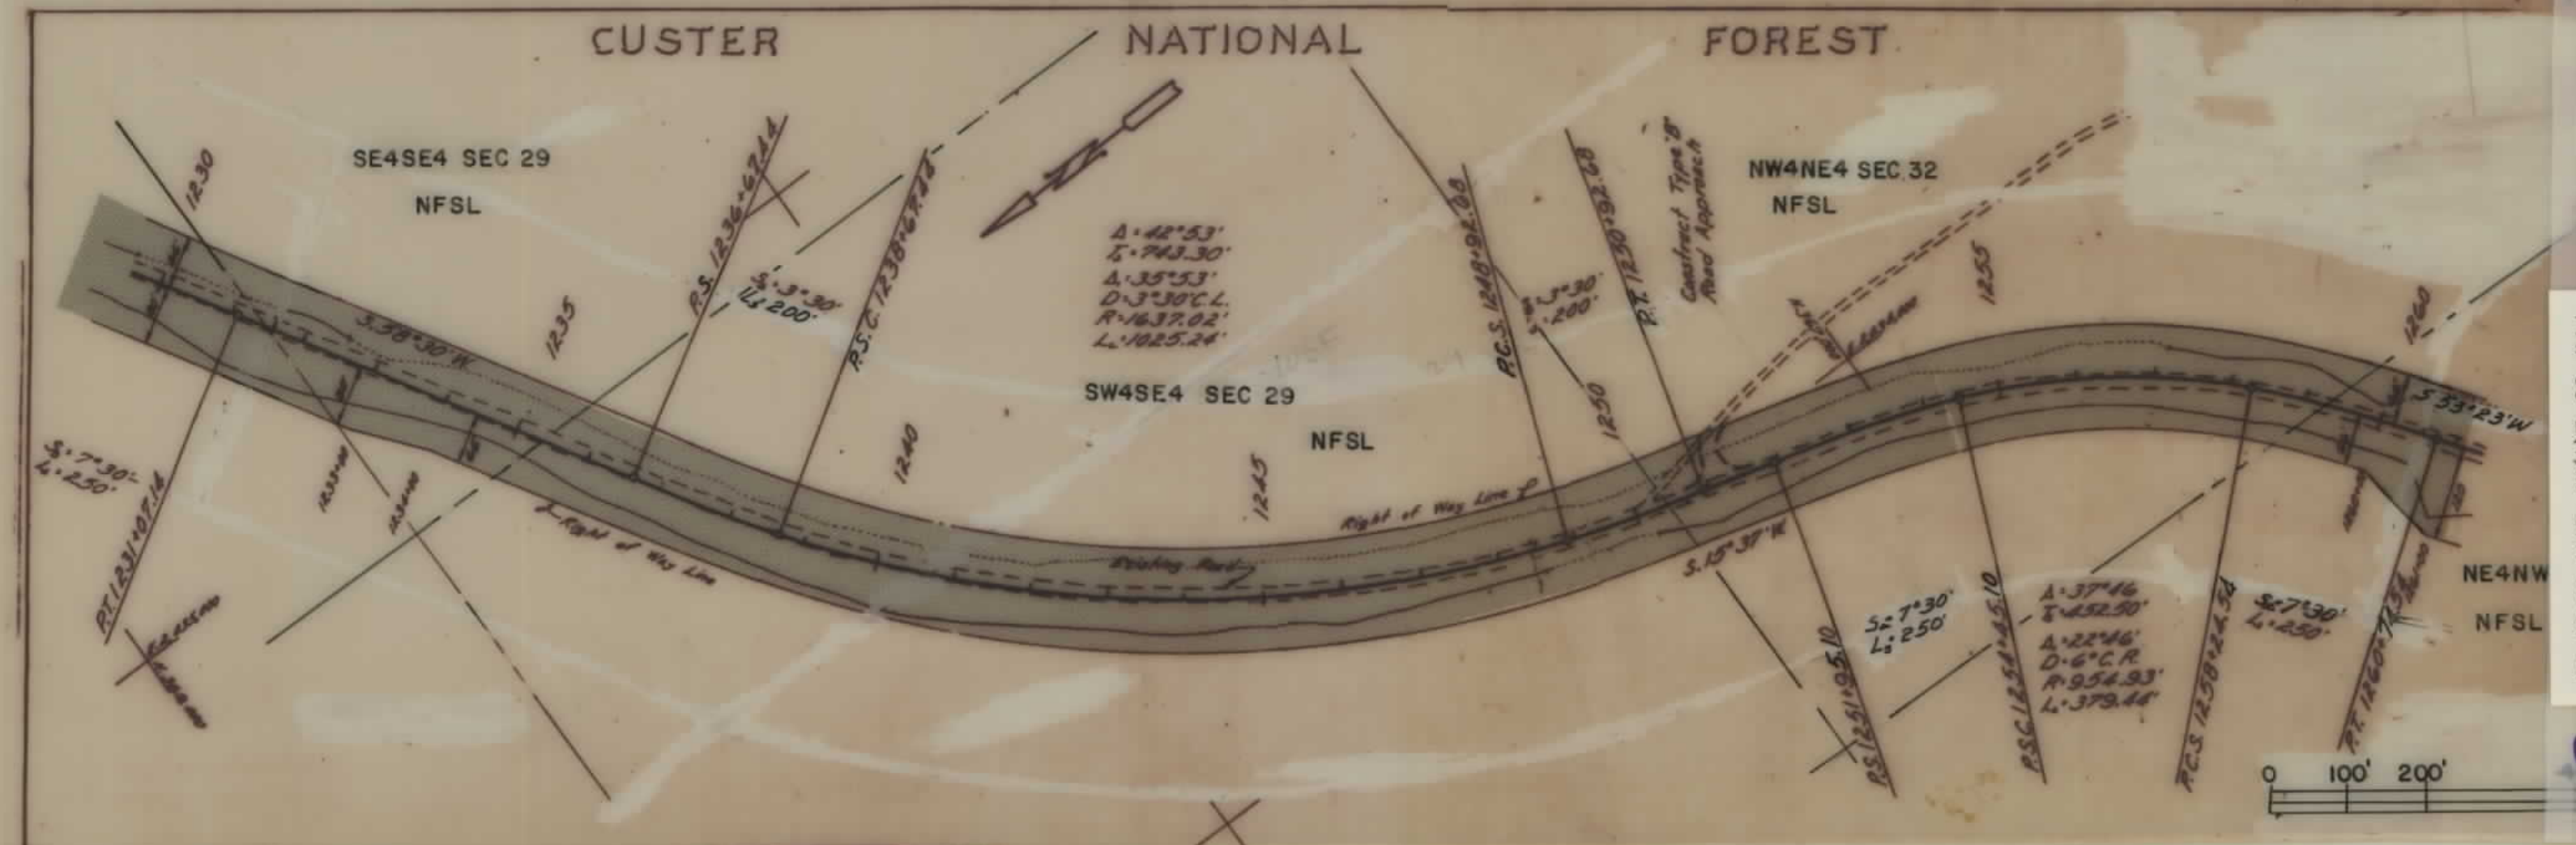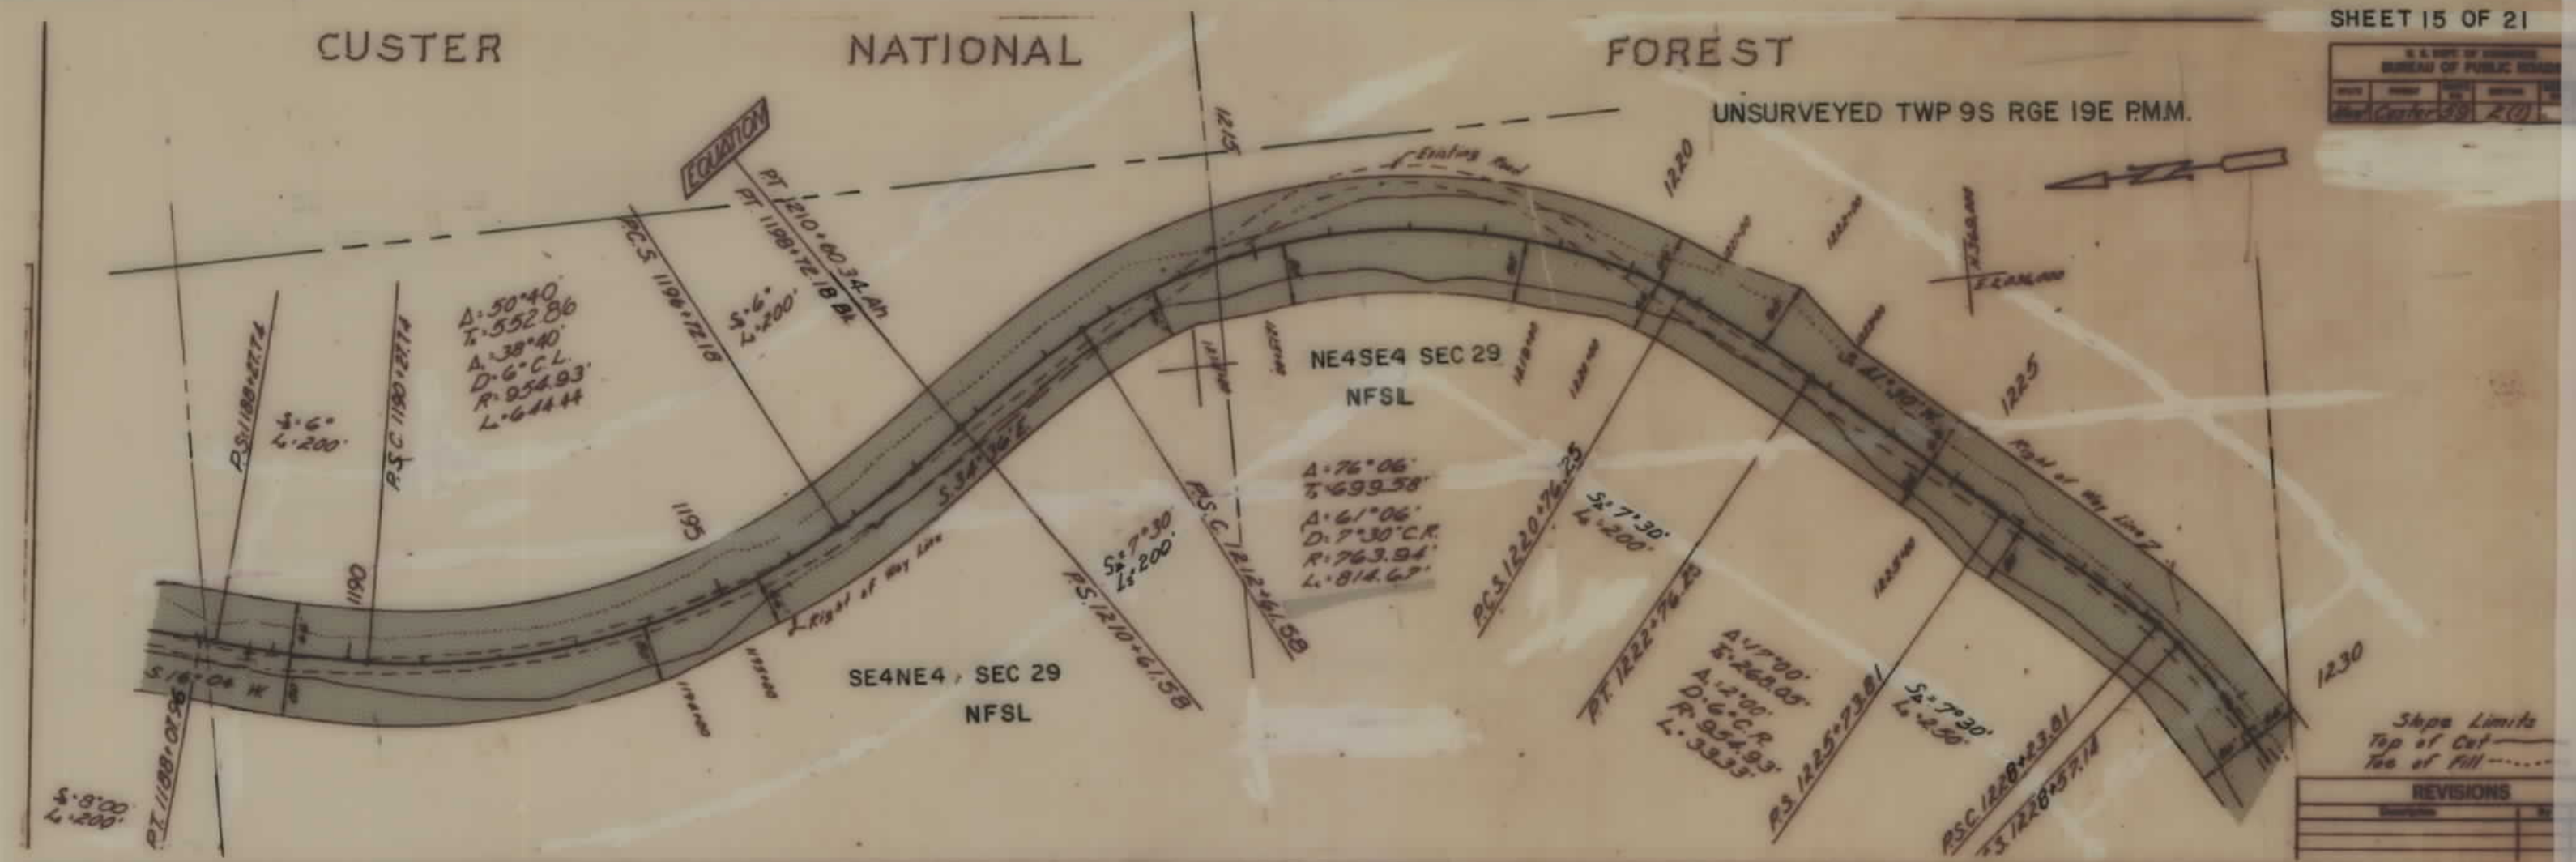


SHOSHONE

NATIONAL

FOREST

GALLATIN

TWP 9S, RGE 15E, P.M.M.

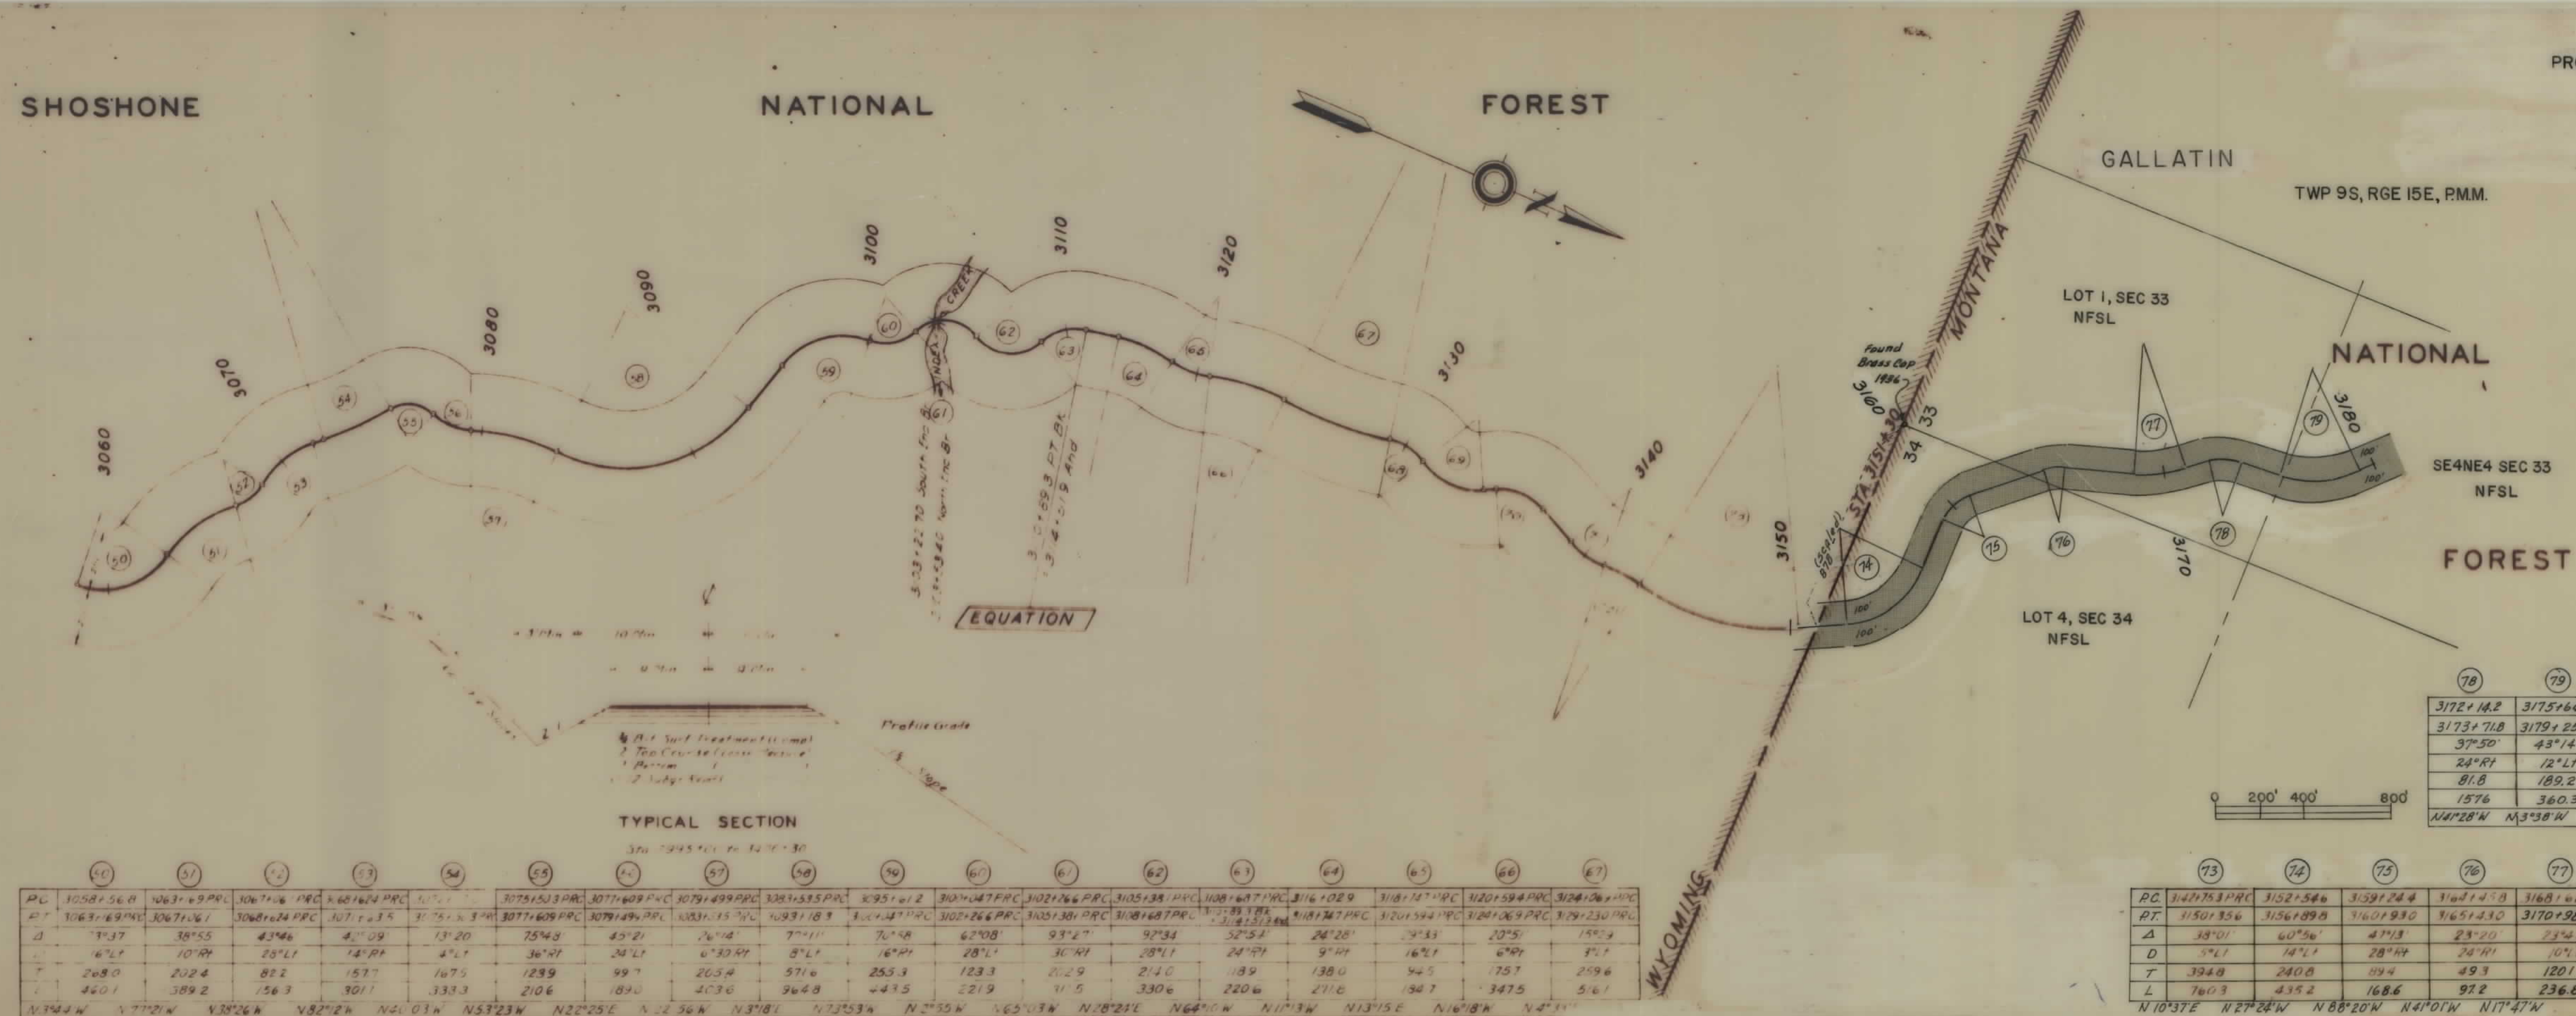

TWP 9S, RGE 15E, P.M.M.

NATIONAL

FOREST

GALLATIN

SW4NE4
NFSL

NE4NW4 SEC 33
NFSL

SE4NE4 SEC 33
NFSL

NW4NE
NFSL

SE4SW4 SEC 28
NFSL

LOT 9, SEC 28
NFSL

LOT 7
NFSL

SW4NW4
NFSL

NE4NW4 SEC 29
NFSL

SE4SW4 SEC 20
NFSI

 
Found Brass T-1494
Cap-GLO 1936 L-2754
1/2 S80

WS. & P. CO.
POWER PLAN

260

CABIN CREEK
 $\Delta - 30^{\circ} 01'$
 $D - 2^{\circ} 47'$
 $T - 76.81$
 15008

S. B. WYMAN

[illegible]

GALLATIN

NATIONAL

FOREST

TWP 9S, RGE 15E, PMM.

TWP 9S, RGE 14E, PMM.

NE4NW4 SEC 29
NFSL

SE4SW4 SEC 20
NFSL

SW4SW4 SEC 20
NFSL

NW4NW4 SEC 29
NFSL

NE4NE4 SEC 30
NFSL

SE4SE4 SEC 19
NFSL

SW4SE4
NFSL

NW4NE4
NFSL

LOT 1, SEC 30
NFSL

LOT 2, SEC 30
NFSL

FAIRVIEW
MILL SITE

HORSESHOE
& GREELEY
PLACER


ONE CACHE
MILLSITE


COOKE

LOT 32, SEC 25
NFSL

BLUEBIRD PLACER # 3716
(NOT PATENTED)
CHRISTOPHER W YOUNGMAN

96	97	98	99	100	101	102	103	104	105	106	107	108	109	110	111	112
P.C. 3327+36.7	3331+07.3	3337+59.1	3339+02.3	3344+44.8	3346+49.4	3349+75.5	3352+96.1	3355+88.3	3364+37.3	3368+07.5	3371+19.8	3376+02.9	3383+07.9	3393+03.8	3396+65.6	3413+59.6
P.T. 3330+63.6	3334+50.8	3339+02.3	3344+42.7	3346+45.9	3349+75.5	3352+63.5	3354+83.0	3359+74.6	3368+07.5	3371+19.8	3376+02.9	3383+07.9	3393+03.8	3396+65.6	3400+182.6	3415+45.4
Δ 84°59'	123°40'	40°05'	151°18'	78°25'	37°44'	57°36'	26°10'	15°27'	29°37'	43°43'	7°06'	13°38'	42°18'	43°25'	10°25½'	7°26'
D 26°Rt	36°Lt	28°Rt	28°Rt	39°Lt	12°Rt	20°Lt	14°Rt	4°Lt	8°Lt	14°Rt	4°Rt	8°Lt	12°Lt	12°Rt	2°30' Lt	4°Rt
T 201.9	297.3	74.6	799.8	119.9	163.2	157.5	95.1	194.3	189.4	164.2	88.9	85.6	184.7	190.1	209.1	93.0
L 326.9	343.5	143.2	540.4	201.1	314.4	288.0	186.9	386.3	370.2	312.3	177.5	170.4	352.5	361.8	417.0	185.8
N13°14½'W S43°05½'W S3°00½'W N25°41½'W S75°53½'W N66°22½'W S56°01½'W S82°11½'W S66°44½'W S37°07½'W S80°50½'W S87°56½'W S74°18½'W S32°00½'W S75°25½'W S65°00'W																

 

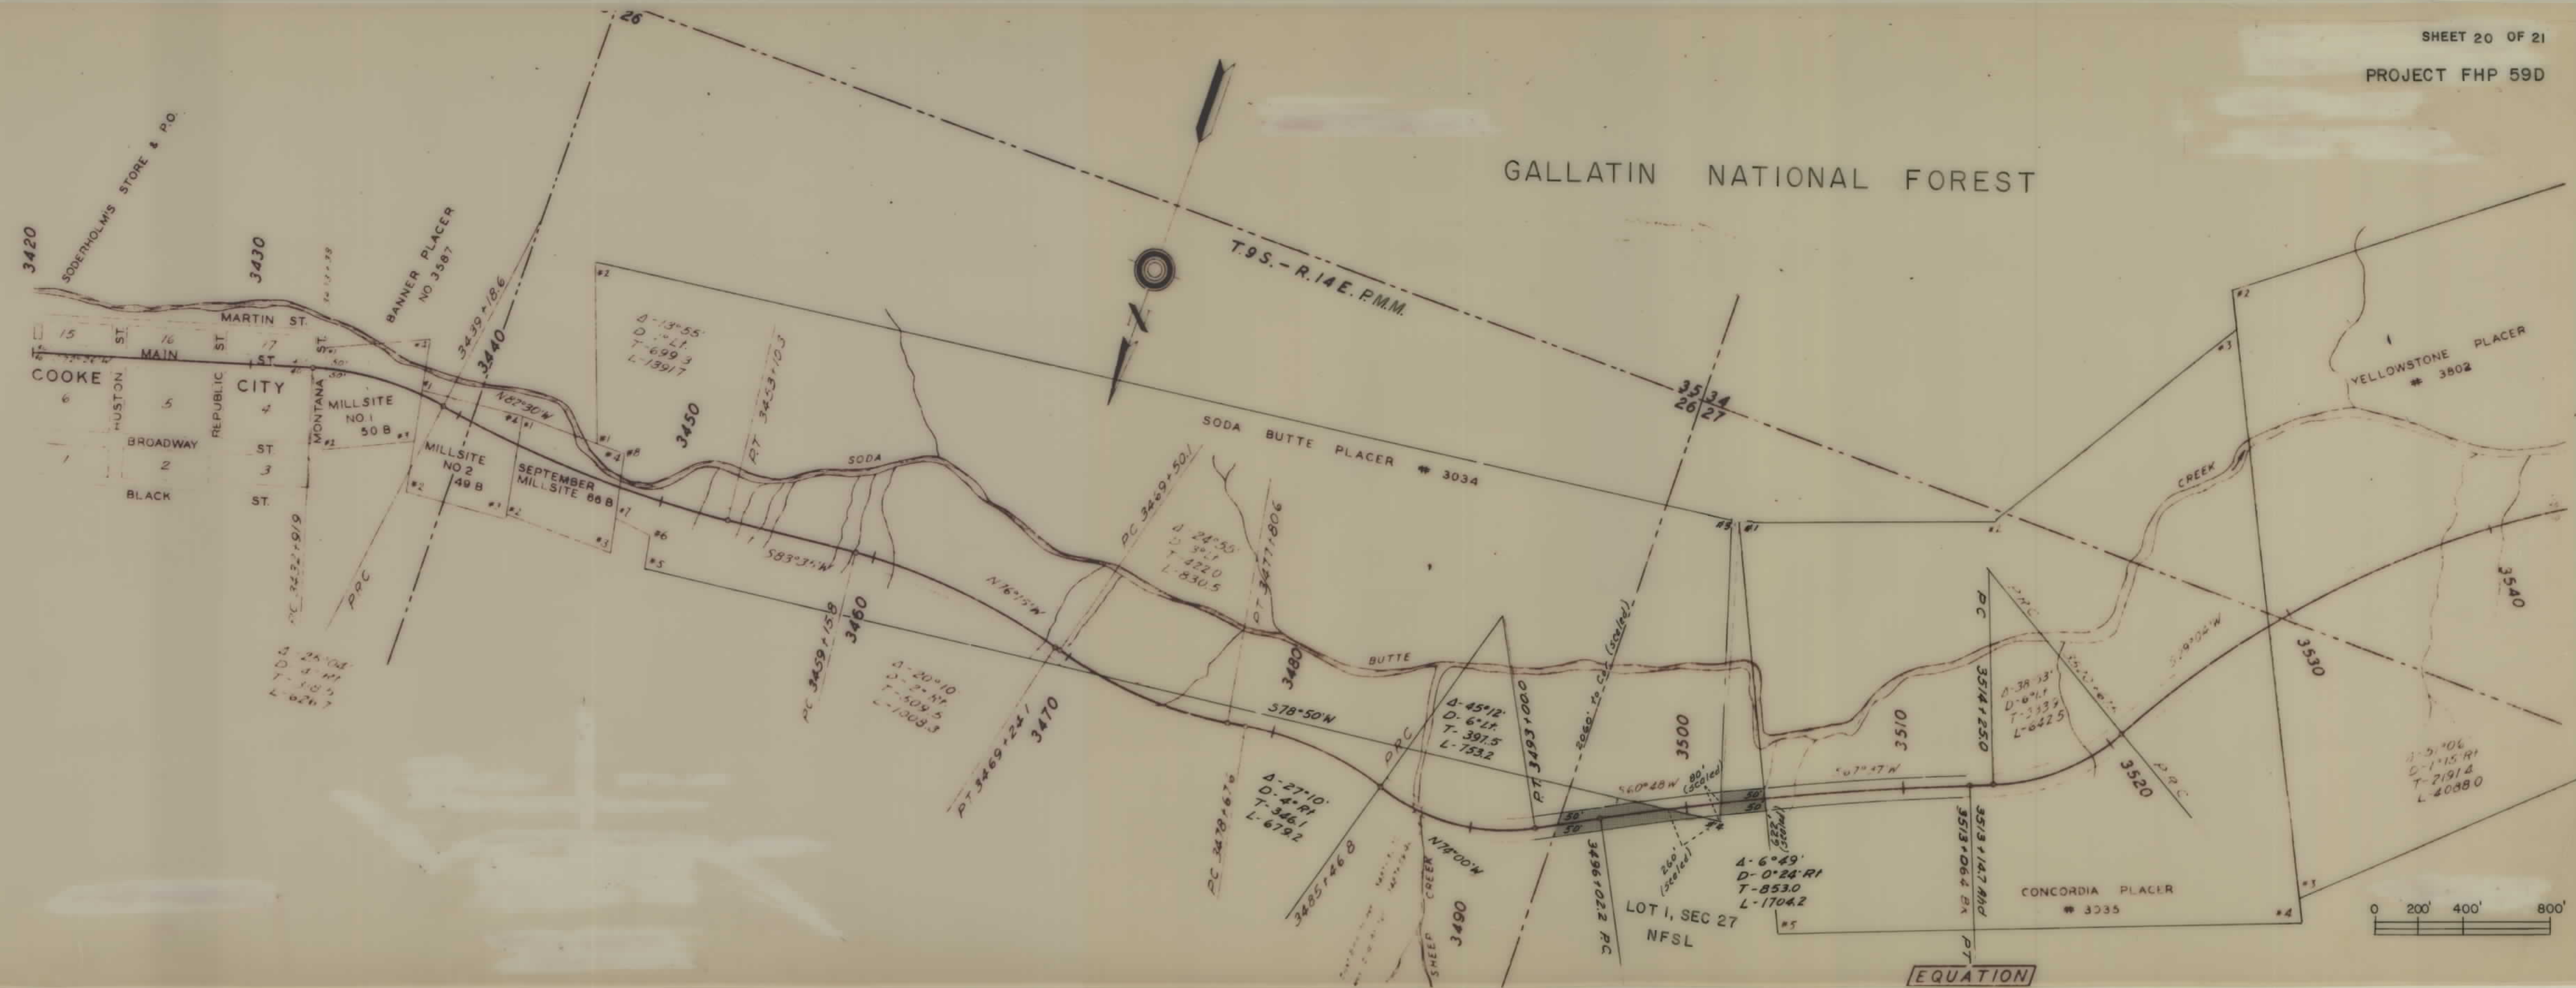



U. S. DEPARTMENT OF TRANSPORTATION
FEDERAL HIGHWAY ADMINISTRATION
REGION 8
"AS CONSTRUCTED" PLANS

